

**ADDENDUM NO. 02
TO THE
BIDDING REQUIREMENTS AND CONTRACT DOCUMENTS
FOR THE
NEW ALBANY UPHILL RUN LIFT STATION PROJECT**

OWNER: City of New Albany
142 East Main Street
New Albany, IN 47150

ISSUED BY/ENGINEER: Beam, Longest and Neff, L.L.C.
8320 Craig Street
Indianapolis, Indiana 46250

ISSUED TO: All Plan and Specifications Holders of Record

ISSUE DATE: November 8, 2021

BID DATE: November 10, 2021

This Addendum No. 02, consisting of 2 pages, shall clarify, correct, or change the Bidding Requirements or the proposed Contract Documents. This Addendum is a part of the Bidding Requirements and the proposed Contract Documents and shall govern in the performance of the Work.

PART 1 - PROJECT MANUAL - NONE

PART 2 - DRAWINGS

2.1 ELECTRICAL DRAWINGS

1. Sheets E-01 through E-05 have been updated – revision are clouded for reference.
2. Sheets E-06 through E-12 have been updated and replaced entirely for clarity.

PART 3 - ADDITIONAL TECHNICAL INFORMATION - NONE

Except as modified by this Addendum and other Addenda, the Bidding Requirements and the proposed Contract Documents shall remain unchanged. You will receive no other notification of this Addendum. **RECEIPT OF THIS ADDENDUM MUST BE ACKNOWLEDGED IN SECTION 00410 - BID FORM, PAGE 00410-1.**



11/8/21

CERTIFIED BY:

Peter Wamsley

Peter Wamsley, P.E.
Registered P.E. No. 11300326
State of Indiana

Encls.: Sheets E-01 through E-12




PROJECT LOCATION
SCALE: 1" = 300'



DRAWING INDEX


SHT. NO.	DESCRIPTION
E-01	LOCATION PLAN AND DRAWING INDEX
E-02	EXISTING LIFT STATION ELECTRICAL DEMO PLAN
E-03	ELECTRICAL SITE PLAN
E-04	PUMP STATION ELECTRICAL PLAN
E-05	ELECTRICAL ONE-LINE DIAGRAM
E-06	PLC PUMP CONTROL PANEL DETAILS
E-07	PUMP CONTROL PANEL POWER WIRING DIAGRAM
E-08	PUMP CONTROL PANEL POWER WIRING DIAGRAM
E-09	PUMP CONTROL PANEL WIRING DIAGRAM
E-10	PUMP CONTROL PANEL POWER WIRING DIAGRAM
E-11	ELECTRICAL DETAILS
E-12	ELECTRICAL DETAILS

REVISIONS AND ISSUES	DATE	BY
1-INITIAL DESIGN, INITIAL AND FINAL CONSTRUCTION, MATERIAL CHECKS	11-08-2021	DMB
2-CORRECTED, REDESIGNED E-12		

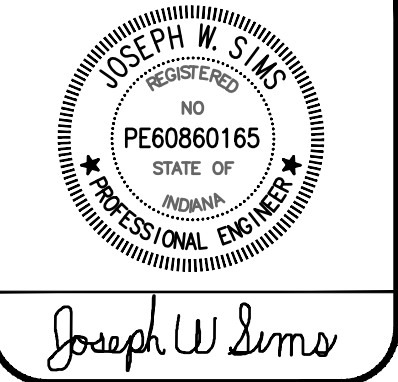



- GENERAL ELECTRICAL NOTES:

- A. CONTRACTOR SHALL COORDINATE ALL REQUIREMENTS FOR NEW SERVICE WITH LOCAL UTILITY. UTILITY CONTACT INFORMATION:
REMCM, PHONE: 812-248-7504
- B. ALL UNDERGROUND CONDUITS SHALL BE SCH 80 PVC.
- C. ALL CONDUITS SWEEPS TO ABOVE GROUND SHALL BE GALVANIZED RIGID STEEL.
- D. ALL CONDUITS ABOVE GRADE EXPOSED OUTDOORS SHALL BE RIGID ALUMINUM; COAT CONDUITS WHERE NECESSARY WHERE IN CONTACT WITH EARTH OR CONCRETE.
- E. SEE ONE LINE DIAGRAM FOR ADDITIONAL DETAILS AND REQUIREMENTS.
- F. PROVIDE LINK SEAL FOR ALL CONDUIT PENETRATIONS INTO LIFT STATION WET WELL.
- G. PROVIDE STAINLESS STEEL HARDWARE FOR ALL EQUIPMENT INSTALLED IN WET WELL; THIS INCLUDES BUT NOT LIMITED TO KELLUM'S CABLE GRIPS, CABLE RACKS, MOUNTING BRACKETS, BOLTS & NUTS.

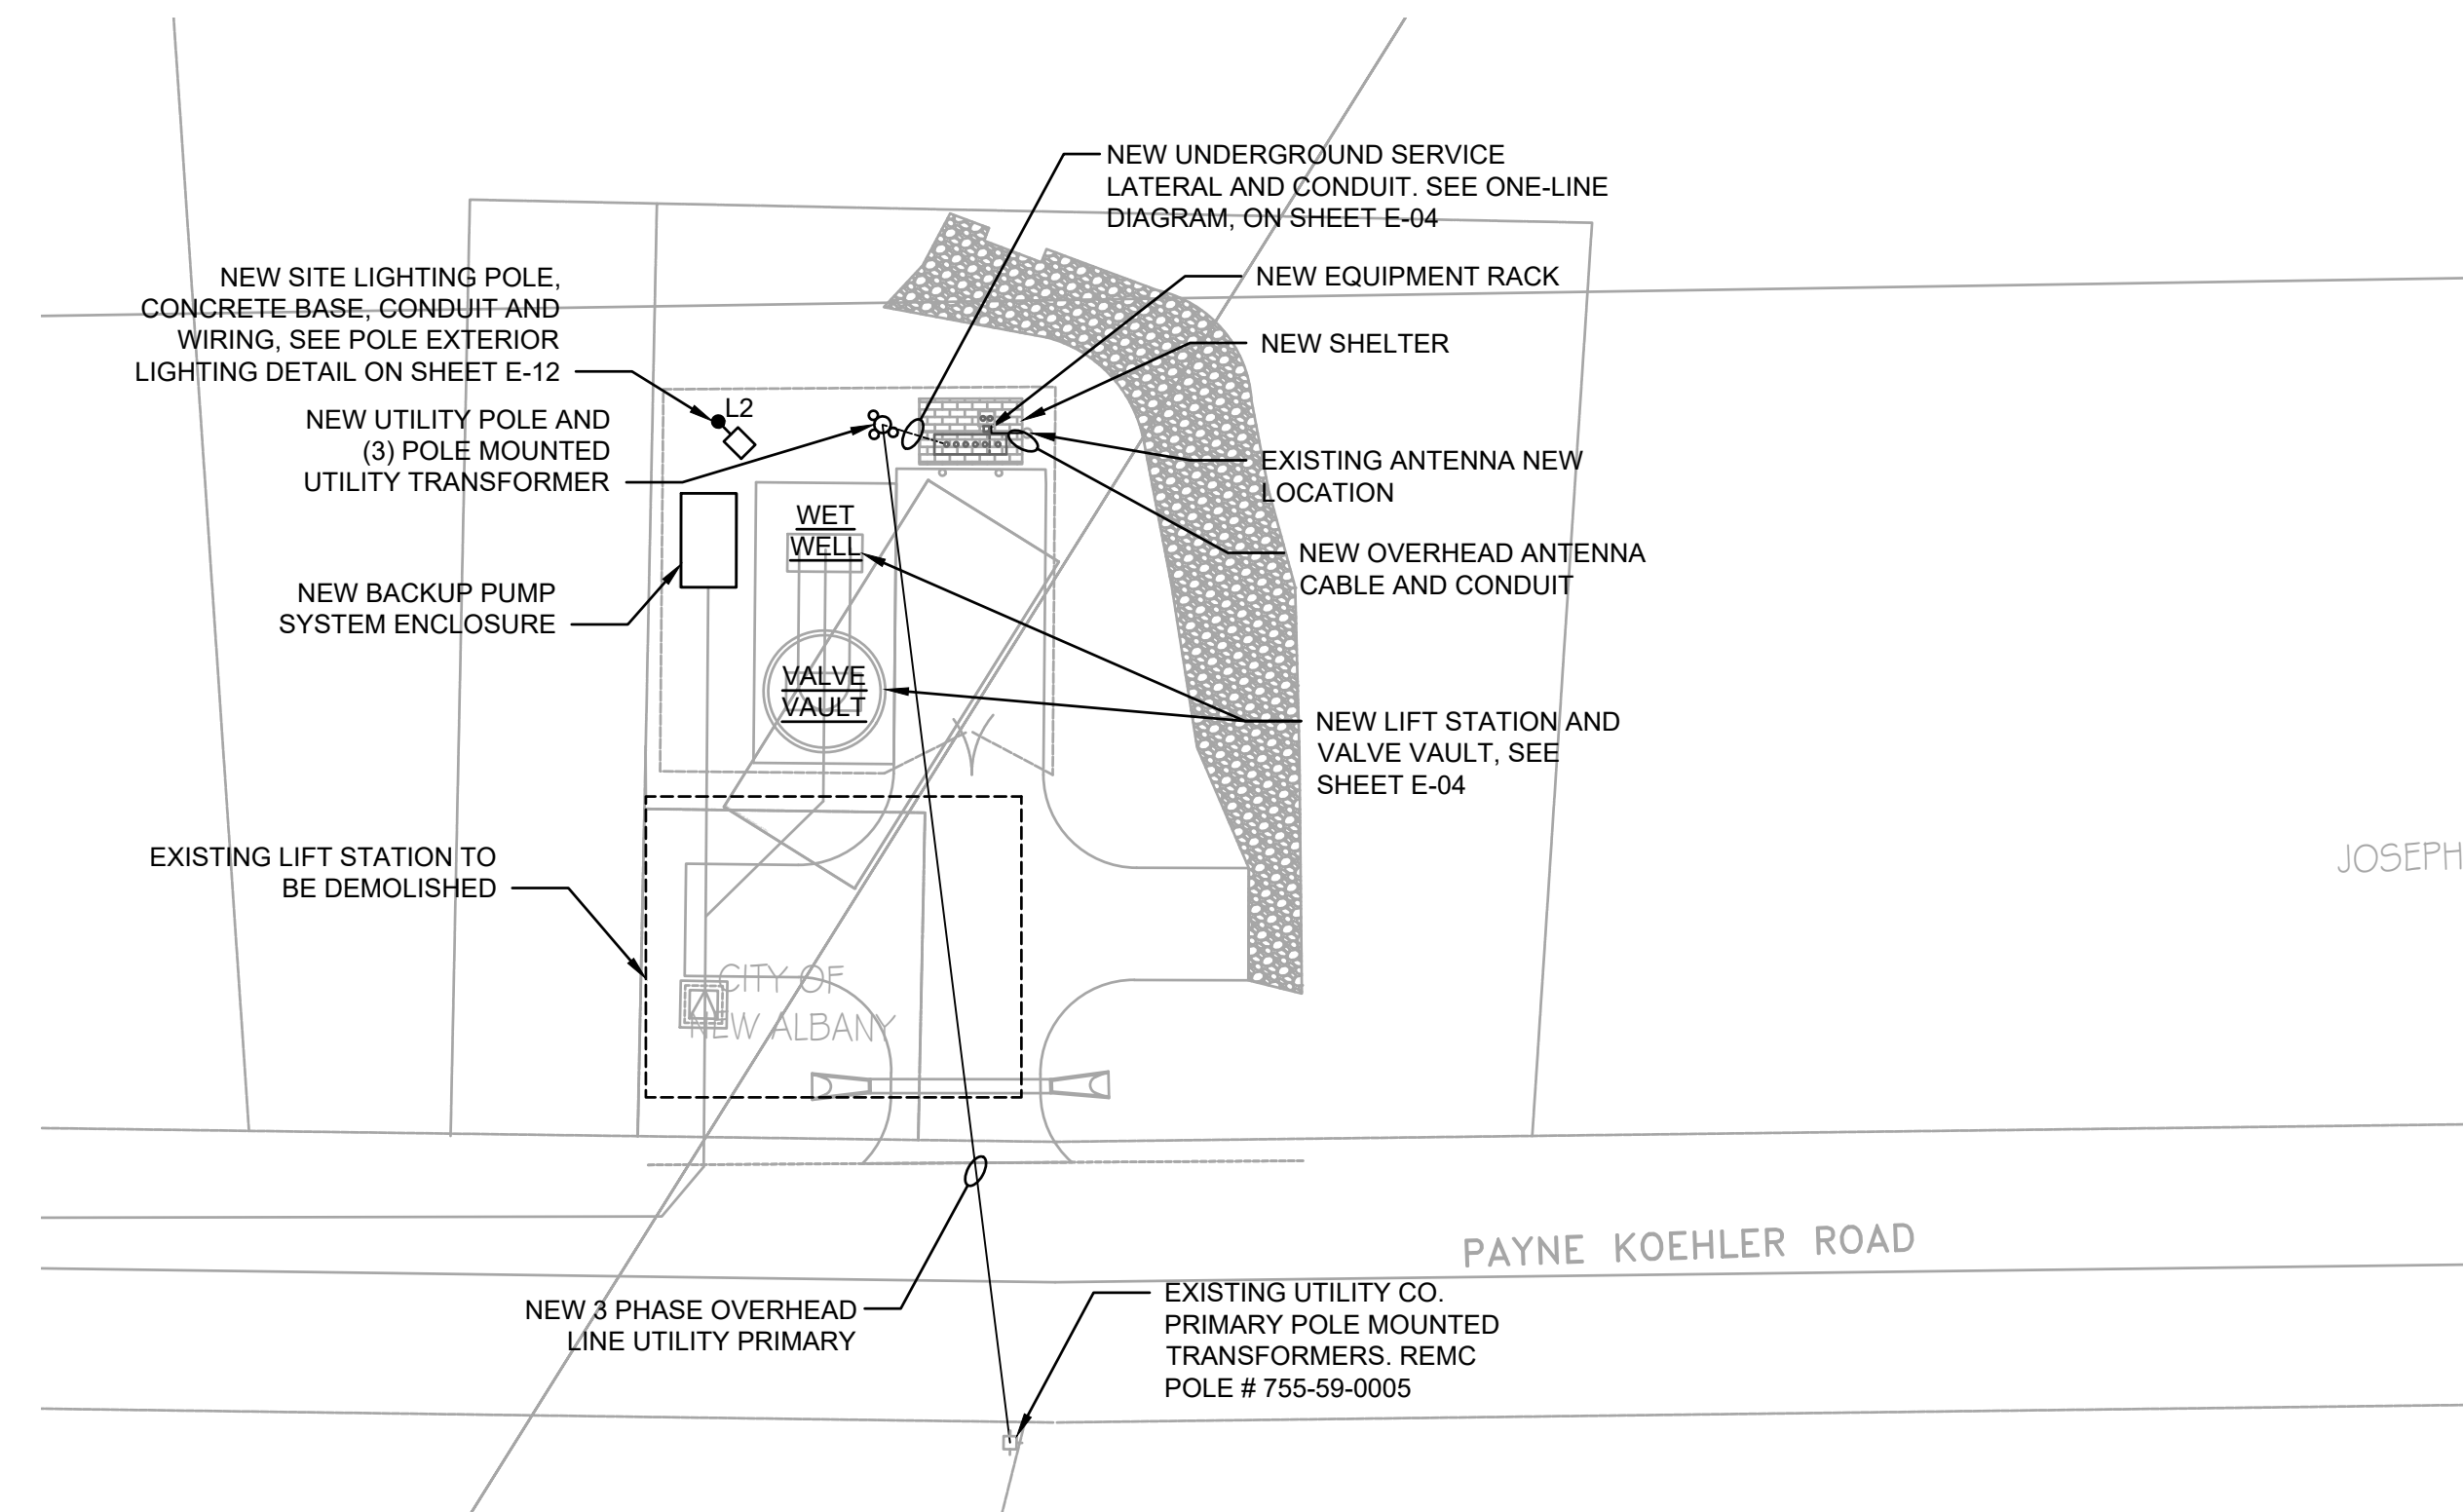

ELECTRICAL SITE PLAN


SCALE: 1" = 20'-0" WHEN PLOTTED FULL SIZE (24" X 36")

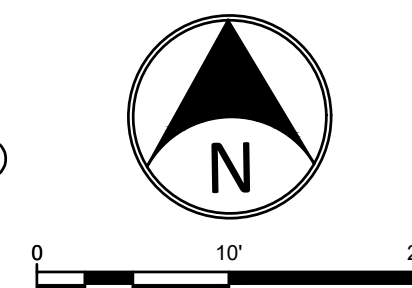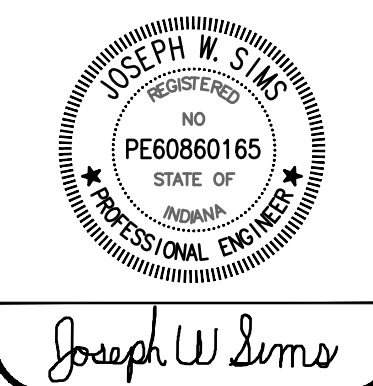[illegible]

Joseph W Sims

**UPHILL RUN LIFT
STATION PROJECT**
200 Commercial St. Nashville, IN. 47448
CITY OF NEW ALBANY WASTEWATER
10th STREET, NEW ALBANY, INDIANA 4
ELECTRICAL SITE PLAN

PLAN DATE: NOVEMBER 8, 2021		
DESIGN:	CHECK:	DRAWN:
PROJECT NO. 2018167		
SHEET NO. E-03		

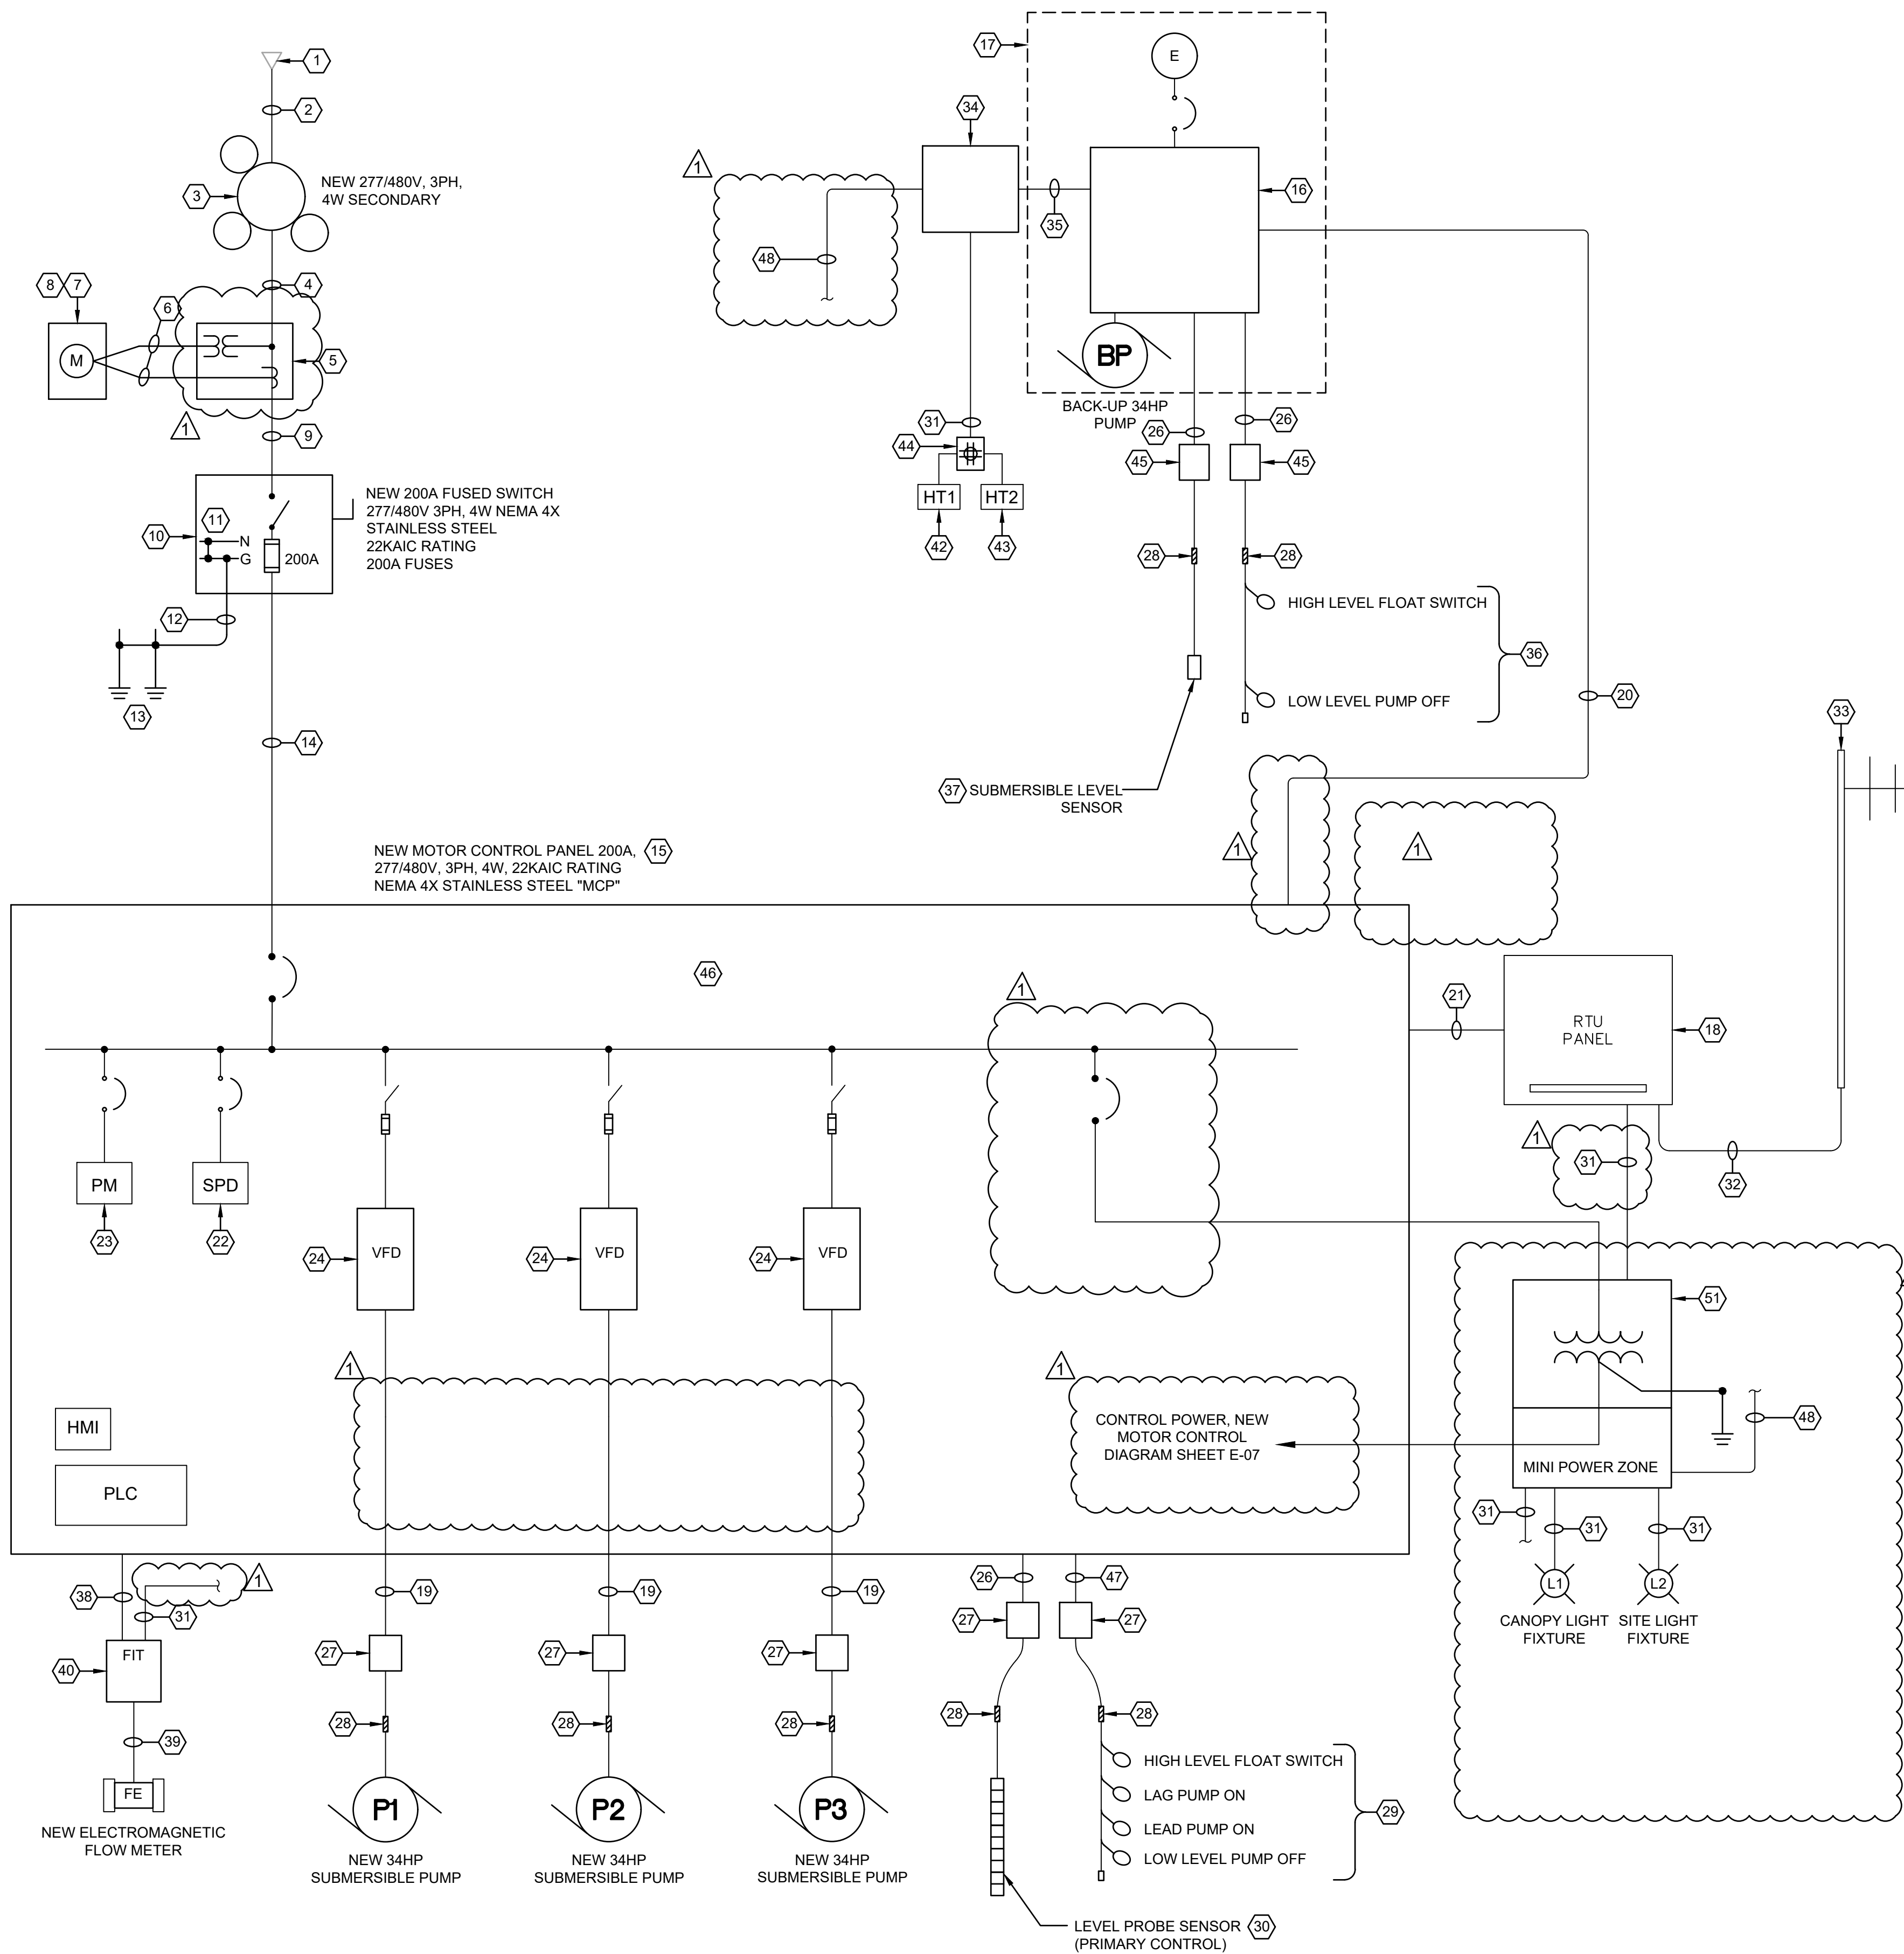

LIFT STATION ONE-LINE DIAGRAM
SCALE: NONE

CONDUIT REQUIREMENT NOTES:

- PROVIDE SCH 80 PVC CONDUITS FOR ALL CONDUITS INSTALLED UNDERGROUND.
- PROVIDE RIGID ALUMINUM CONDUITS FOR ALL OUTDOOR CONDUITS ABOVE FINISHED GRADE AT EQUIPMENT RACK. COAT CONDUITS WHERE IN CONTACT WITH EARTH OR CONCRETE.
- PROVIDE RGS CONDUIT TRANSITIONS FROM BELOW GRADE TO ABOVE GRADE.

ELECTRICAL KEYED NOTES:


- EXISTING ELECTRICAL UTILITY CO. PRIMARY LINE.
- NEW 3-PHASE OVERHEAD LINE UTILITY PRIMARY.
- NEW POLE AND POLE MOUNTED TRANSFORMERS, BY UTILITY. 277/480V, 3PH, 4 WIRE SYSTEM.
- NEW SERVICE LATERAL WIRING PROVIDED BY CONTRACTOR. 4-#3/0 CU, 4"C. COORDINATE WITH UTILITY.
- CTs TO BE LOCATED AT TRANSFORMER SECONDARY NEAR TOP OF POLE BY UTILITY.
- INSTRUMENTATION WIRING BY UTILITY; CONTRACTOR SHALL PROVIDE 2" C.
- METER BASE FURNISHED AND INSTALLED BY CONTRACTOR; COORDINATE REQUIREMENTS WITH UTILITY. METER BASE TO BE MOUNT ON POLE.
- METER FURNISHED AND INSTALLED BY UTILITY.
- 4-#3/0 CU, 2-1/2" C.
- NEW FUSED SWITCH TO BE MOUNTED ON CONTROL RACK.
- BOND NEUTRAL TO GROUND AT THIS LOCATION ONLY.
- #4 BARE CU GROUND ELECTRODE CONDUCTOR, 3/4"C.
- (2) 3/4" DIAM. x 10' LENGTH COPPER CLAD GROUND ROD.
- 4-#3/0 CU, 1-#6 CU GND, 2-1/2" C.
- NEW MOTOR CONTROL PANEL FURNISHED AND INSTALLED BY CONTRACTOR.
- BACKUP ENCLOSURE DRIVEN PUMP CONTROL PANEL.
- BACKUP PUMP DIESEL ENGINE SYSTEM.
- RELOCATE EXISTING RTU AT NEW LIFT STATION. SEE SHEET E-12 FOR ADDITIONAL INFORMATION.
- 3-#2 XHHW-2 CU, 1-#8 CU GND, 1-1/2" C.
- NOT AUTO, 2-#14 CU, COMMON ALARM, 2-#14 CU, WEAK BATTERY, 2-#14 CU, LOW FUEL, 2-#14 CU, ENGINE RUNNING, 2-#14 CU, 1-#14 CU GND, 2" C.
- ALARM AND MONITORING SIGNALS FROM PUMP CONTROL PANEL TO TELEMTRY PANEL, 28 - #14 CU, 1 1/2" C. SEE SHEET E-10.
- INTEGRAL SURGE PROTECTION DEVICE.
- POWER MONITOR DEVICE
- PROVIDE ULTRA LOW HARMONIC VARIABLE FREQUENCY DRIVE (VFDs).
- NOT USED.
- LEVEL PROBE CABLE IN 2" C.
- NEW VENTED TERMINAL BOX; SEE DETAIL #1 ON SHEET E-11.
- J-HOOKS, KELLEMS GRIPS, MOUNTING BRACKETS, AND STAIN RELIEF DEVICE, STAINLESS STEEL.
- FLOAT SWITCHES FURNISHED AND INSTALLED BY CONTRACTOR.
- LEVEL PROBE SENSOR FURNISHED AND INSTALLED BY CONTRACTOR. EQUAL TO MULTITRODE XYLEM OR APPROVED EQUAL.
- 2-#12 CU, 1-#12 CU GND, 3/4" C.
- INSTALL EXISTING, RELOCATED LMR-400 ANTENNA CABLE IN 2" C. TO RTU PANEL.
- EXISTING POLE MOUNTED ANTENNA SHALL BE RELOCATED BY CONTRACTOR.
- NEW NEMA 4X STAINLESS STEEL JUNCTION BOX FOR POWER.
- POWER WIRING AND CONDUITS MULTIPLE CIRCUITS.
- FLOAT SWITCHES FURNISHED BY MANUFACTURER AND INSTALLED BY CONTRACTOR.
- SUBMERSIBLE LEVEL SENSOR FURNISHED BY MANUFACTURER AND INSTALLED BY CONTRACTOR. EC SHALL FURNISH AND INSTALL STILLING TUBE, SEE DETAIL ON SHEET E-11.

SUBMERSIBLE LEVEL TRANSMITTER NOT USED. REMOVE...

GENERAL ELECTRICAL NOTES:

- WET WELL IS CLASS 1 DIVISION 1 GROUP D - ALL WIRING METHODS AND DEVICES MUST COMPLY WITH NEC. HAZARDOUS ENVIRONMENT MEANS AND METHODS.
- 4-20MA ANALOG SIGNAL, FLOW, TSP #16, 3/4" C.
 - INSTRUMENT CABLE, FURNISHED WITH FLOW METER, INSTALLED IN 2" C. BY CONTRACTOR.
 - FLOW INDICATOR TRANSMITTER FURNISHED AND INSTALLED BY CONTRACTOR.
 - NOT USED.
 - NEW HEAT TAPE SYSTEM FOR SUCTION PIPING. SELF REGULATING CHROMALOX. HAZARDOUS AREA TYPE HSRL OR APPROVED EQUAL.
 - NEW HEAT TAPE SYSTEM FOR DISCHARGE PIPING. SELF REGULATING CHROMALOX. HAZARDOUS AREA TYPE HSRL OR APPROVED EQUAL.
 - NEW WP/GFI QUAD RECEPTACLE WITH IN USE COVER FOR HEAT TAPE.
 - NEW VENTED TERMINAL BOX; SEE DETAIL #2 ON SHEET E-11.
 - SEE SHEETS E-06 THRU E-11 FOR ADDITIONAL DETAILS.
 - 8-#14 CU, 1-#14 CU GND, 3/4" C.
 - BACKUP PUMP SYSTEM BLOCK HEATER 2-#12 CU, 1-#12 CU GND, BACKUP PUMP SYSTEM BATTERY CHARGER, 2-#12 CU, 1-#12 CU GND, BACKUP PUMP SYSTEM CONTROL POWER, 2-#12 CU, 1-#12 CU GND, HEAT TRACE CIRCUIT, 2-#12 CU, 1-#12 CU GND, 1" C. PROVIDE 3-#12 SPARES.
 - NOT USED.
 - NOT USED.
 - MINI POWER ZONE; 7KVA, 480V:120/240V, 1PH TRANSFORMER. 60A PANELBOARD WITH MCB. NEMA 3R STAINLESS STEEL.

BY	DATE	REVISIONS AND ISSUES
11-03-2021		

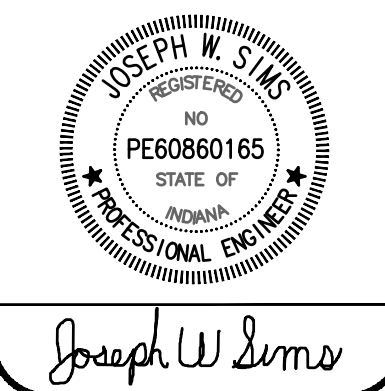

- OPERATE THE DRIVE. KEYPAD SHALL BE SET NORMALLY TO THE AUTO POSITION TO OPERATE. ONCE ALL DRIVE PARAMETERS HAVE BEEN SETUP TO OPERATE NORMALLY, BACKUP PARAMETERS WITHIN THE KEYPAD FUNCTION.
13. 120V CONTROL RELAYS. QUANTITY AS REQUIRED BY PANEL FABRICATOR FINAL DESIGN.
14. SINGLE POLE SUPPLEMENTAL CIRCUIT BREAKERS. SEE WIRING DETAILS.
15. CONTROL PANEL DOOR PILOT DEVICE INTERFACE TERMINAL BLOCKS.
16. 3 POLE CIRCUIT BREAKER FOR 3 PHASE POWER MONITOR.
17. PHASE FAIL MONITOR.
18. 3 POLE CIRCUIT BREAKER FOR 3 PHASE SURGE PROTECTION DEVICE.
19. 3 PHASE SURGE PROTECTOR. FOR REFERENCE, SQUARE D TVS4HWA50X SHOWN.
20. WIRE DUCT — AS REQUIRED.
21. 2 POLE CIRCUIT BREAKER FOR LOCAL CONTROL POWER TRANSFORMER.
22. ULTRA-LOW HARMONIC (ULH) VFD DRIVES FOR 34HP SUBMERSIBLE PUMPS. ABB ACQ580-31-052A-4 WITH ETHERNET MODBUS TCP/IP SHOWN.
23. NON-METALLIC HOUSING FOR ISB EQUIPMENT.
24. FLOAT SWITCH INTRINSICALLY SAFETY BARRIER SIMILAR TO IDEC EB3C-R05AN.
25. NEMA4X ALARM BEACON.
26. PANEL EARTH GROUND COMMON BLOCK.



45. ML1400 ANALOG OUTPUT CARD.
46. PLC DIGITAL INPUT FIELD TERMINATION BLOCKS.
47. PLC DIGITAL OUTPUT ISOLATION RELAYS.
48. PLC ANALOG INPUT/OUTPUT TERMINATION BLOCKS. 3 LEVEL WITH SIGNAL GROUND.
49. MULTITRODE EIC MODULE.
50. FIELD TERMINATION BLOCKS FOR MOTOR PROTECTION SEAL FAIL AND OVERTEMP SENSOR CABLES.
51. UNMANAGED ETHERNET SWITCH.
52. FIELD DEVICE RELAYS TO SPLIT CRITICAL ALARM SIGNALS TO PLC AND TELEMETRY ALARM SERVICE.

PUMP CONTROL PANEL IS FOR A TRIPLEX LIFT STATION. ONLY 2 PUMPS WILL OPERATE AT A TIME WITH THE THIRD BEING A STANDBY. ALTERNATE LEAD/LAG USING ALL THREE PUMPS.




SCALE: NONE

THE PANEL LAYOUT SHOWN IS INTENDED TO ESTABLISH THE SCOPE OF WORK AND EXPECTATIONS. FINAL LAYOUT AND DETAILS SHALL BE THE RESPONSIBILITY OF THE MOTOR CONTROL PANEL FABRICATOR. SUBMIT SHOP DRAWINGS FOR REVIEW.

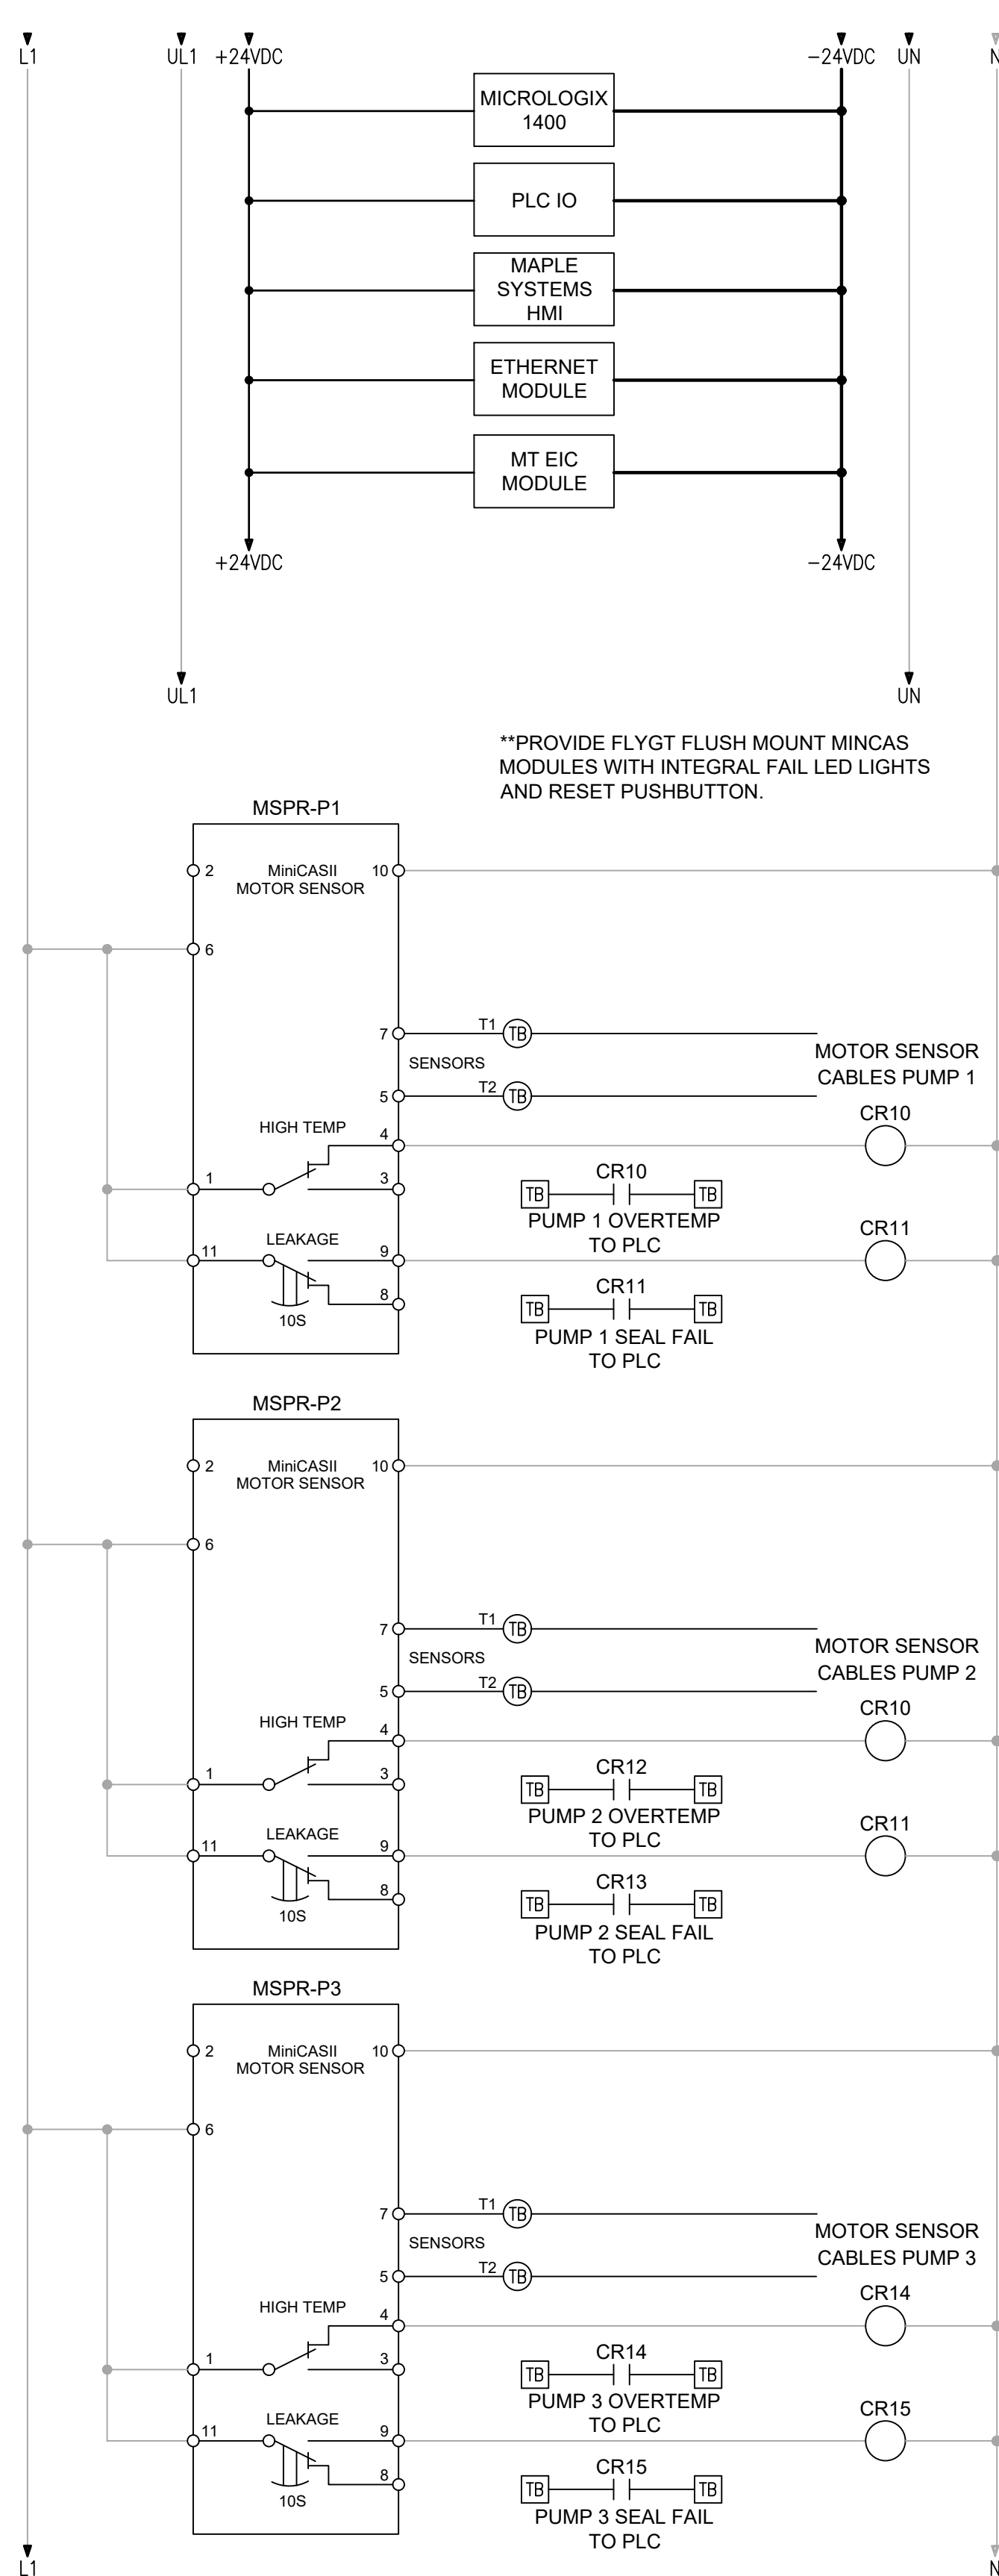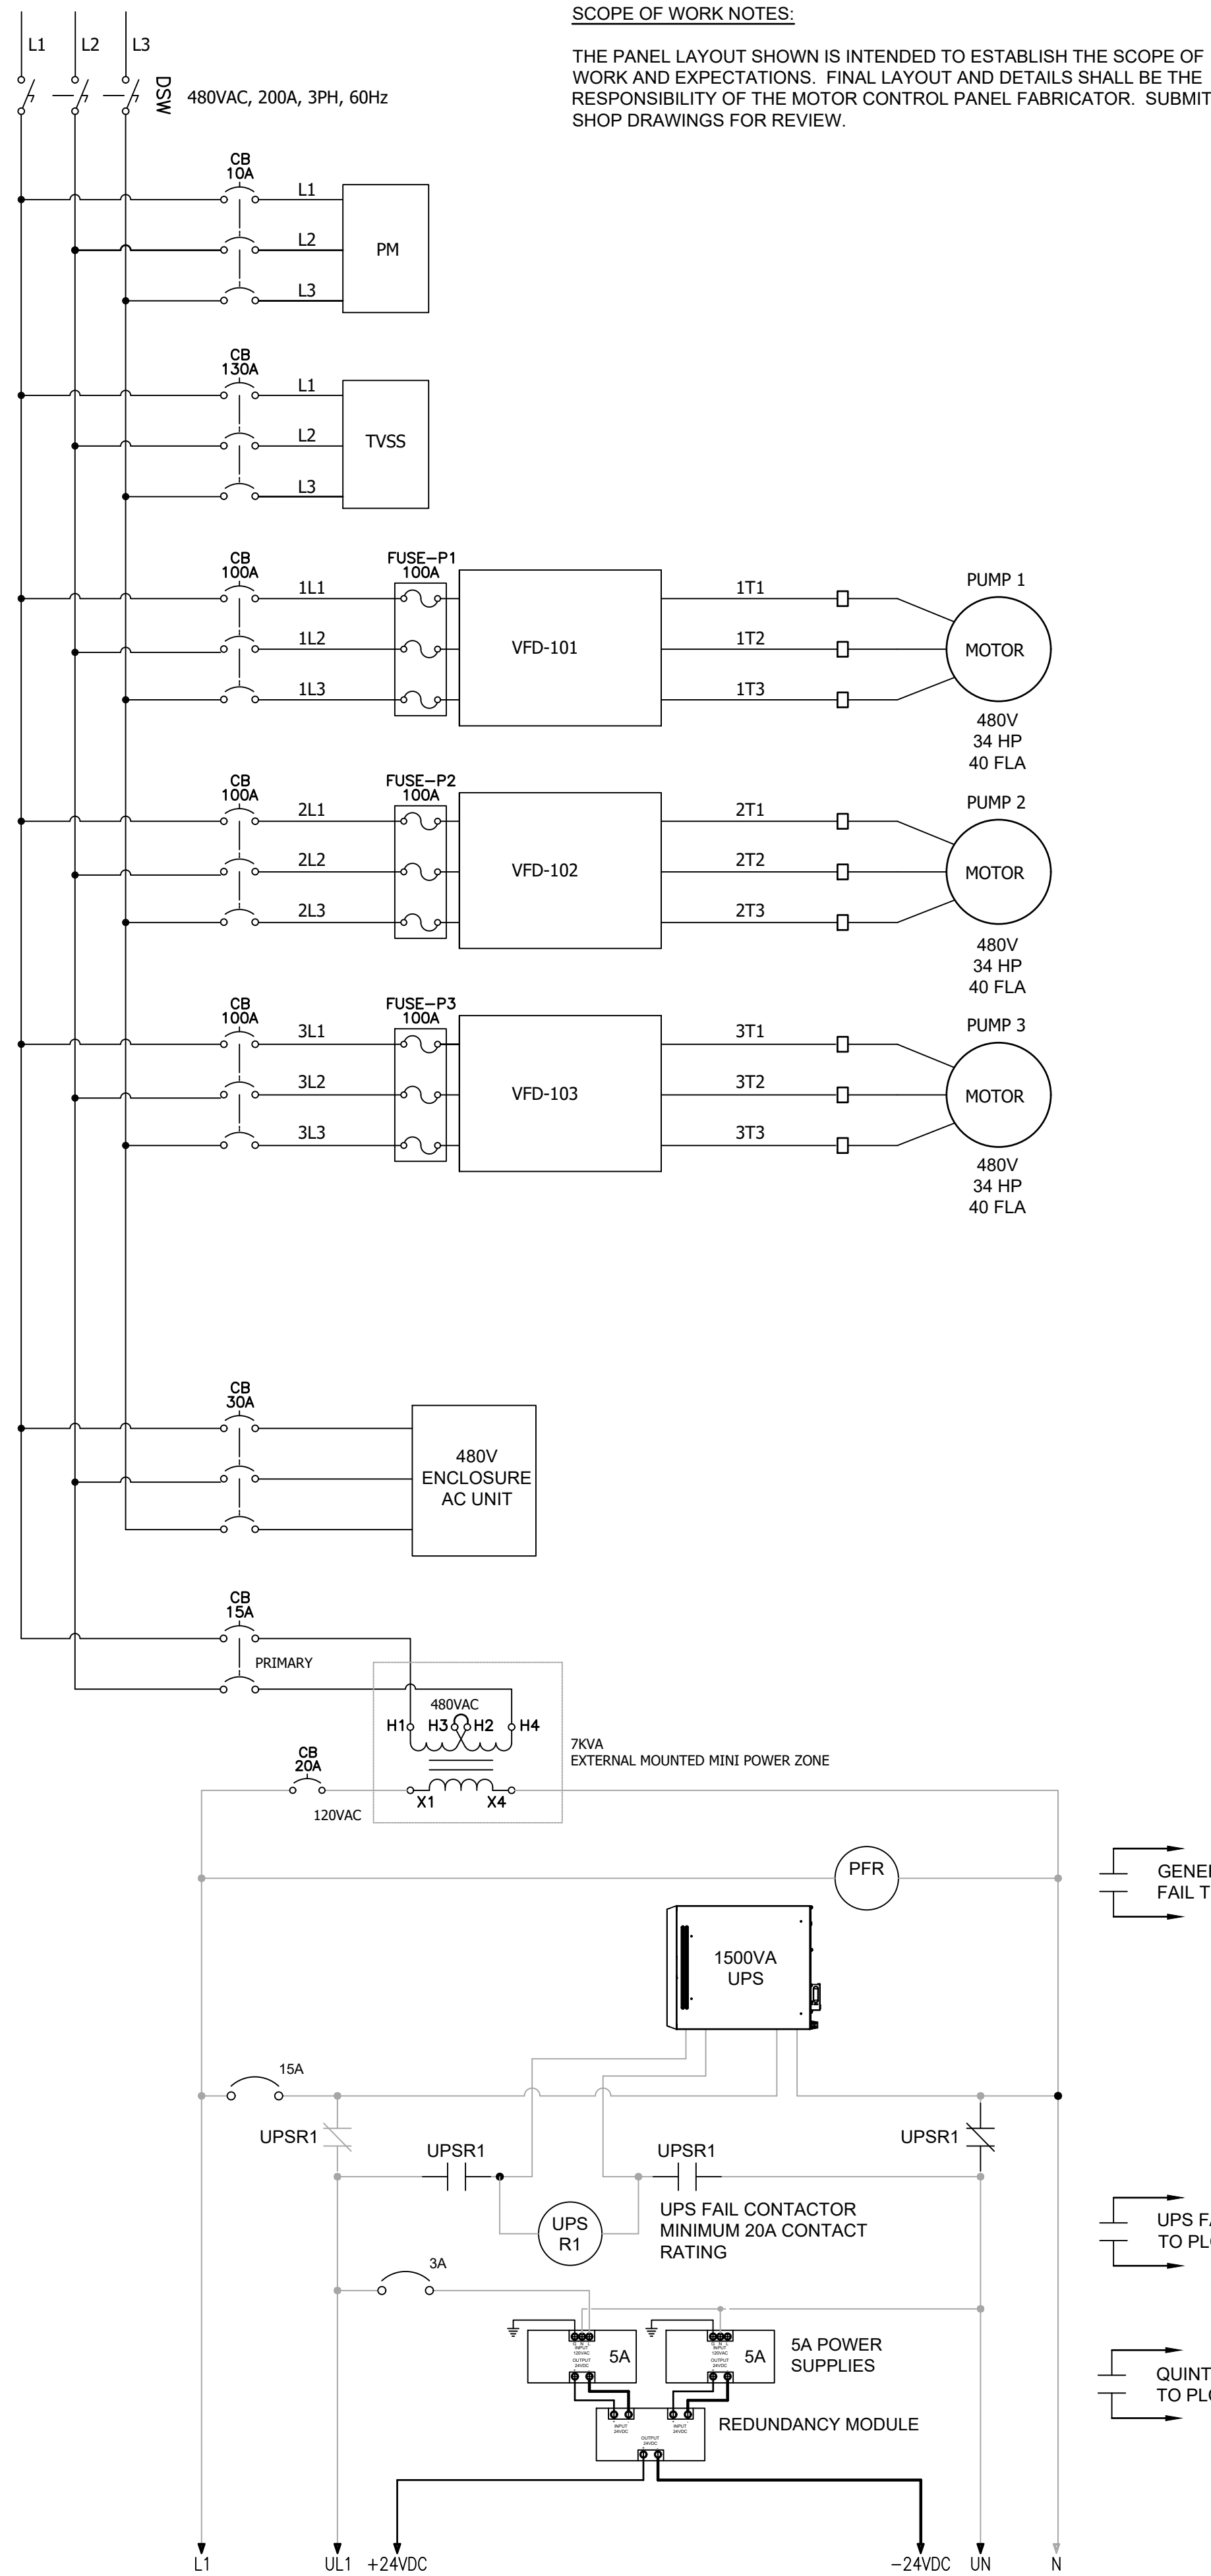

**PROVIDE FLYGT FLUSH MOUNT MINCAS MODULES WITH INTEGRAL FAIL LED LIGHTS AND RESET PUSHBUTTON.

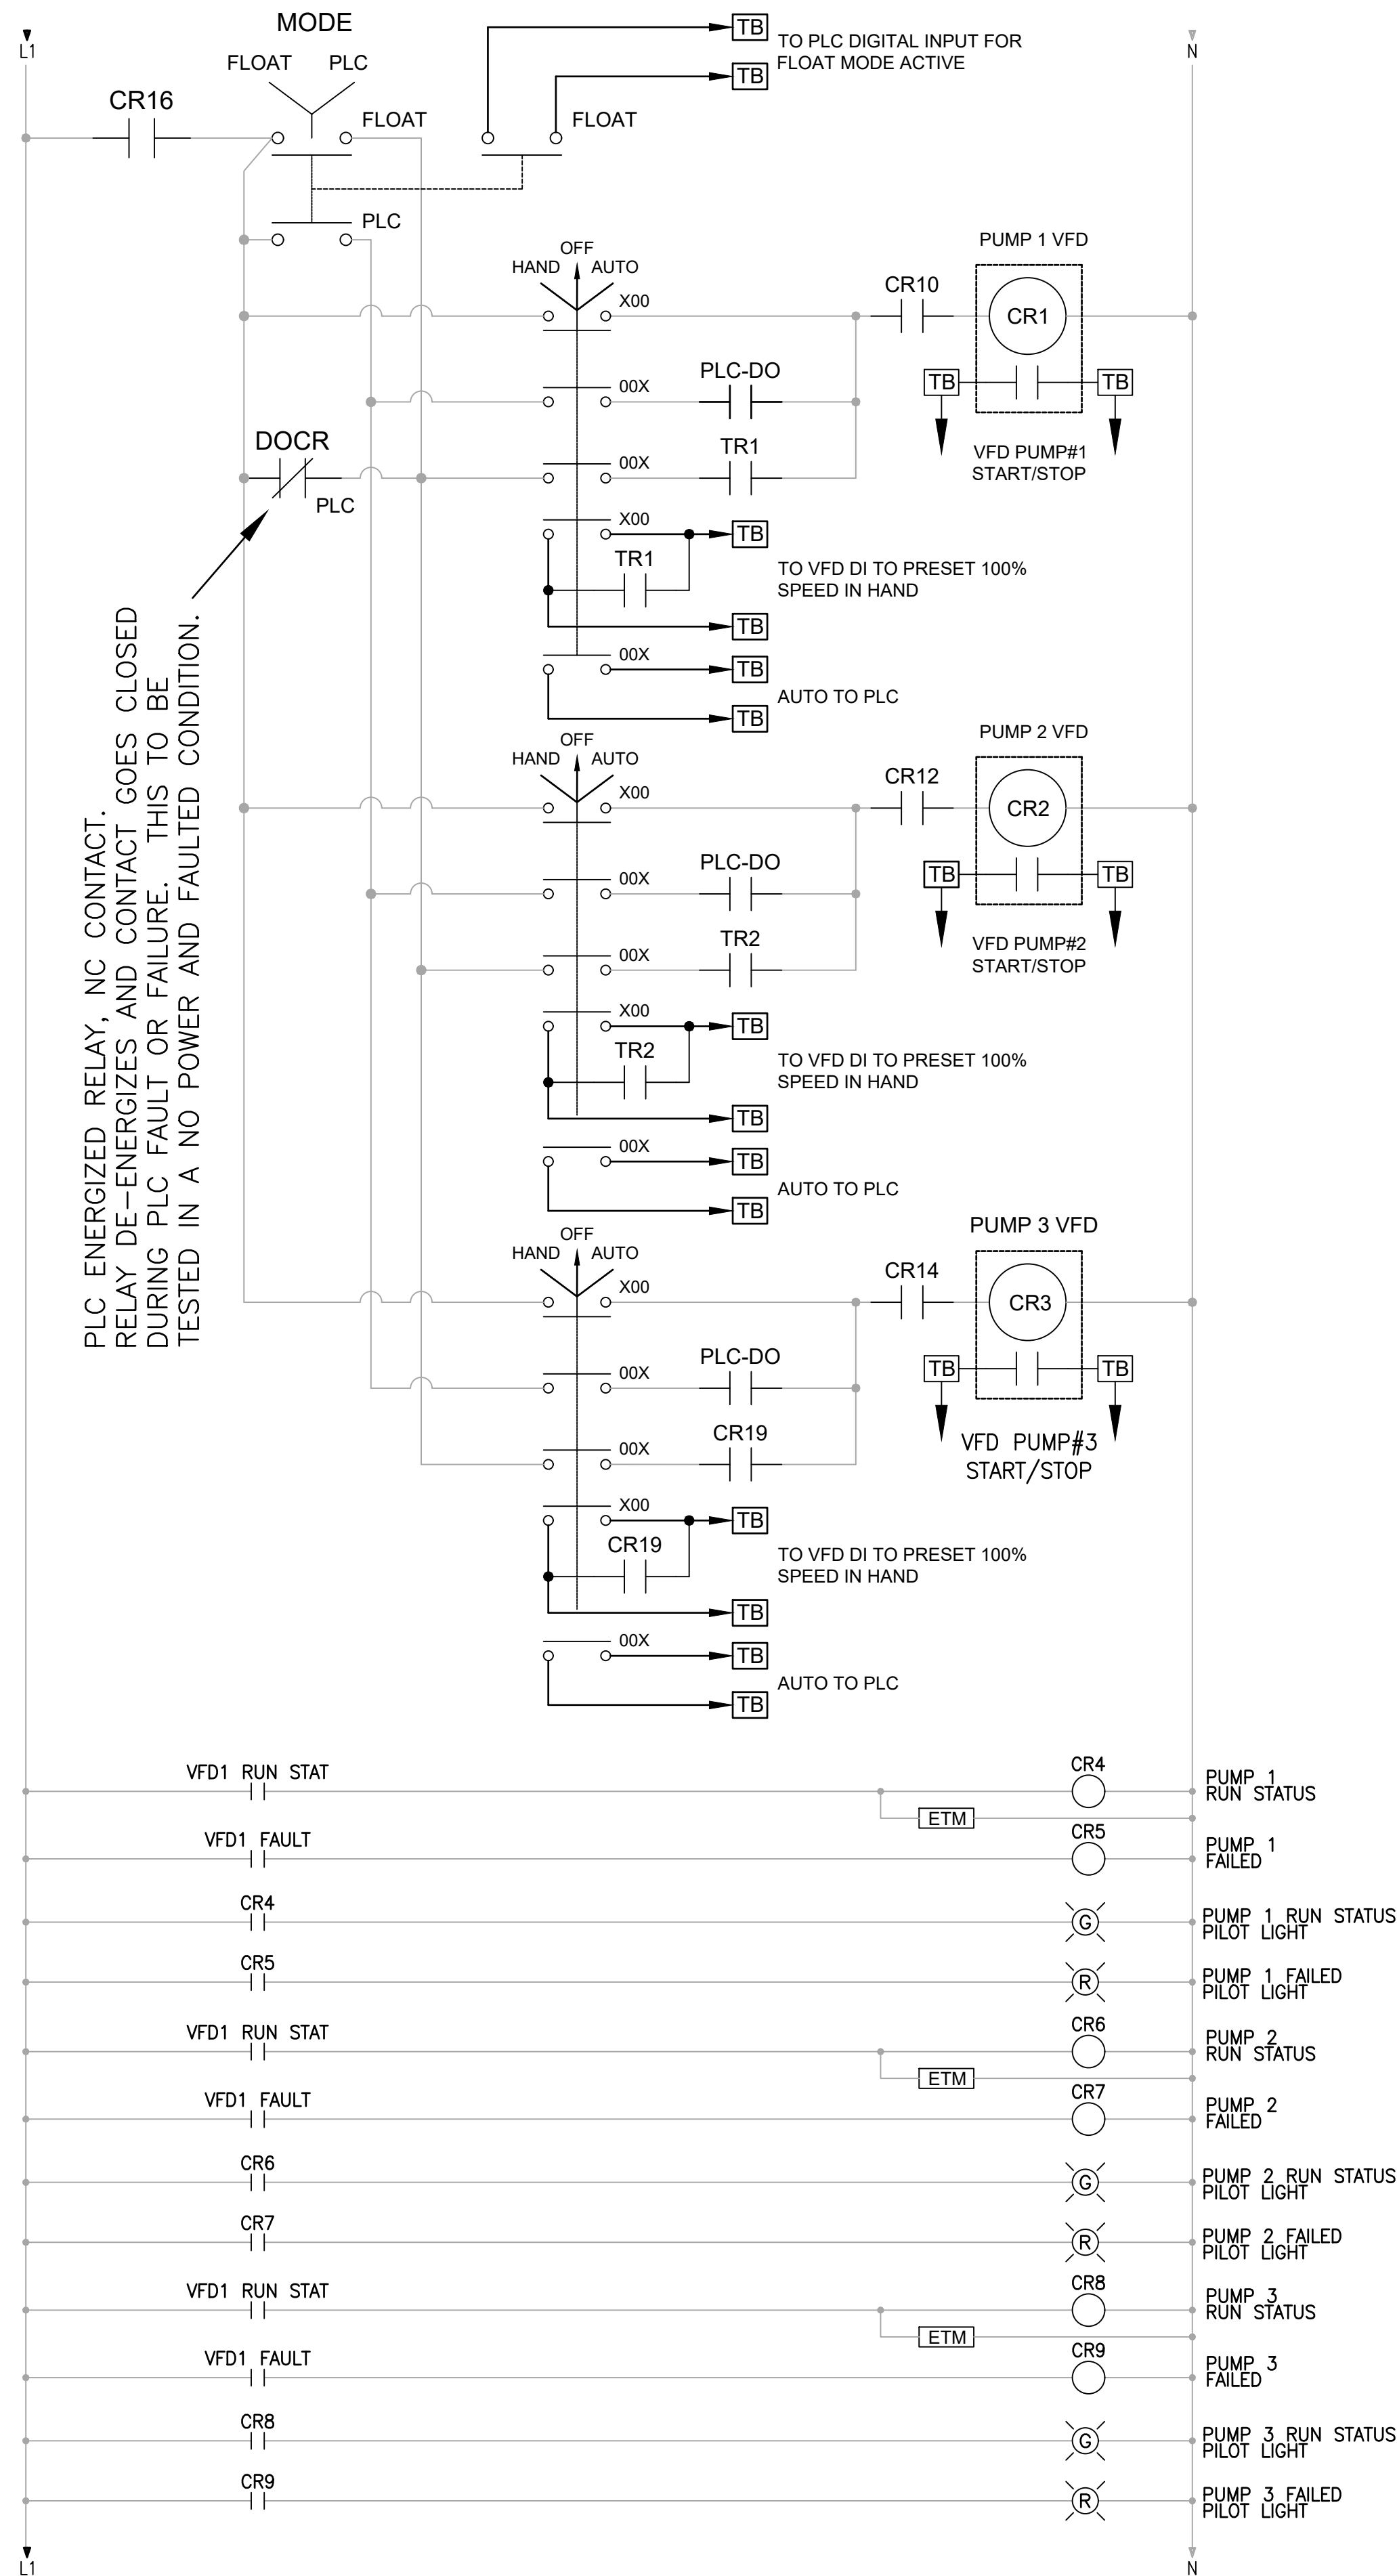

PUMP CONTROL PANEL WIRING DIAGRAM
SCALE: NONE

8195 Cassidon Road, Indianapolis, IN 46250
Phone: 317.494.9001
www.bl-n.com




DATE	BY	APP
11-05-2021		

Joseph W. Sims

UPHILL RUN LIFT
STATION PROJECT
200 Commercial St. Nashville, IN. 47448
CITY OF NEW ALBANY WASTEWATER
38 W. 10th STREET, NEW ALBANY, INDIANA 47150

PUMP CONTROL PANEL WIRING DIAGRAM

PLAN DATE: NOVEMBER 8, 2021
DESIGN: CHECK: DRAWN:
PROJECT NO. 2018167
SHEET NO. E-07

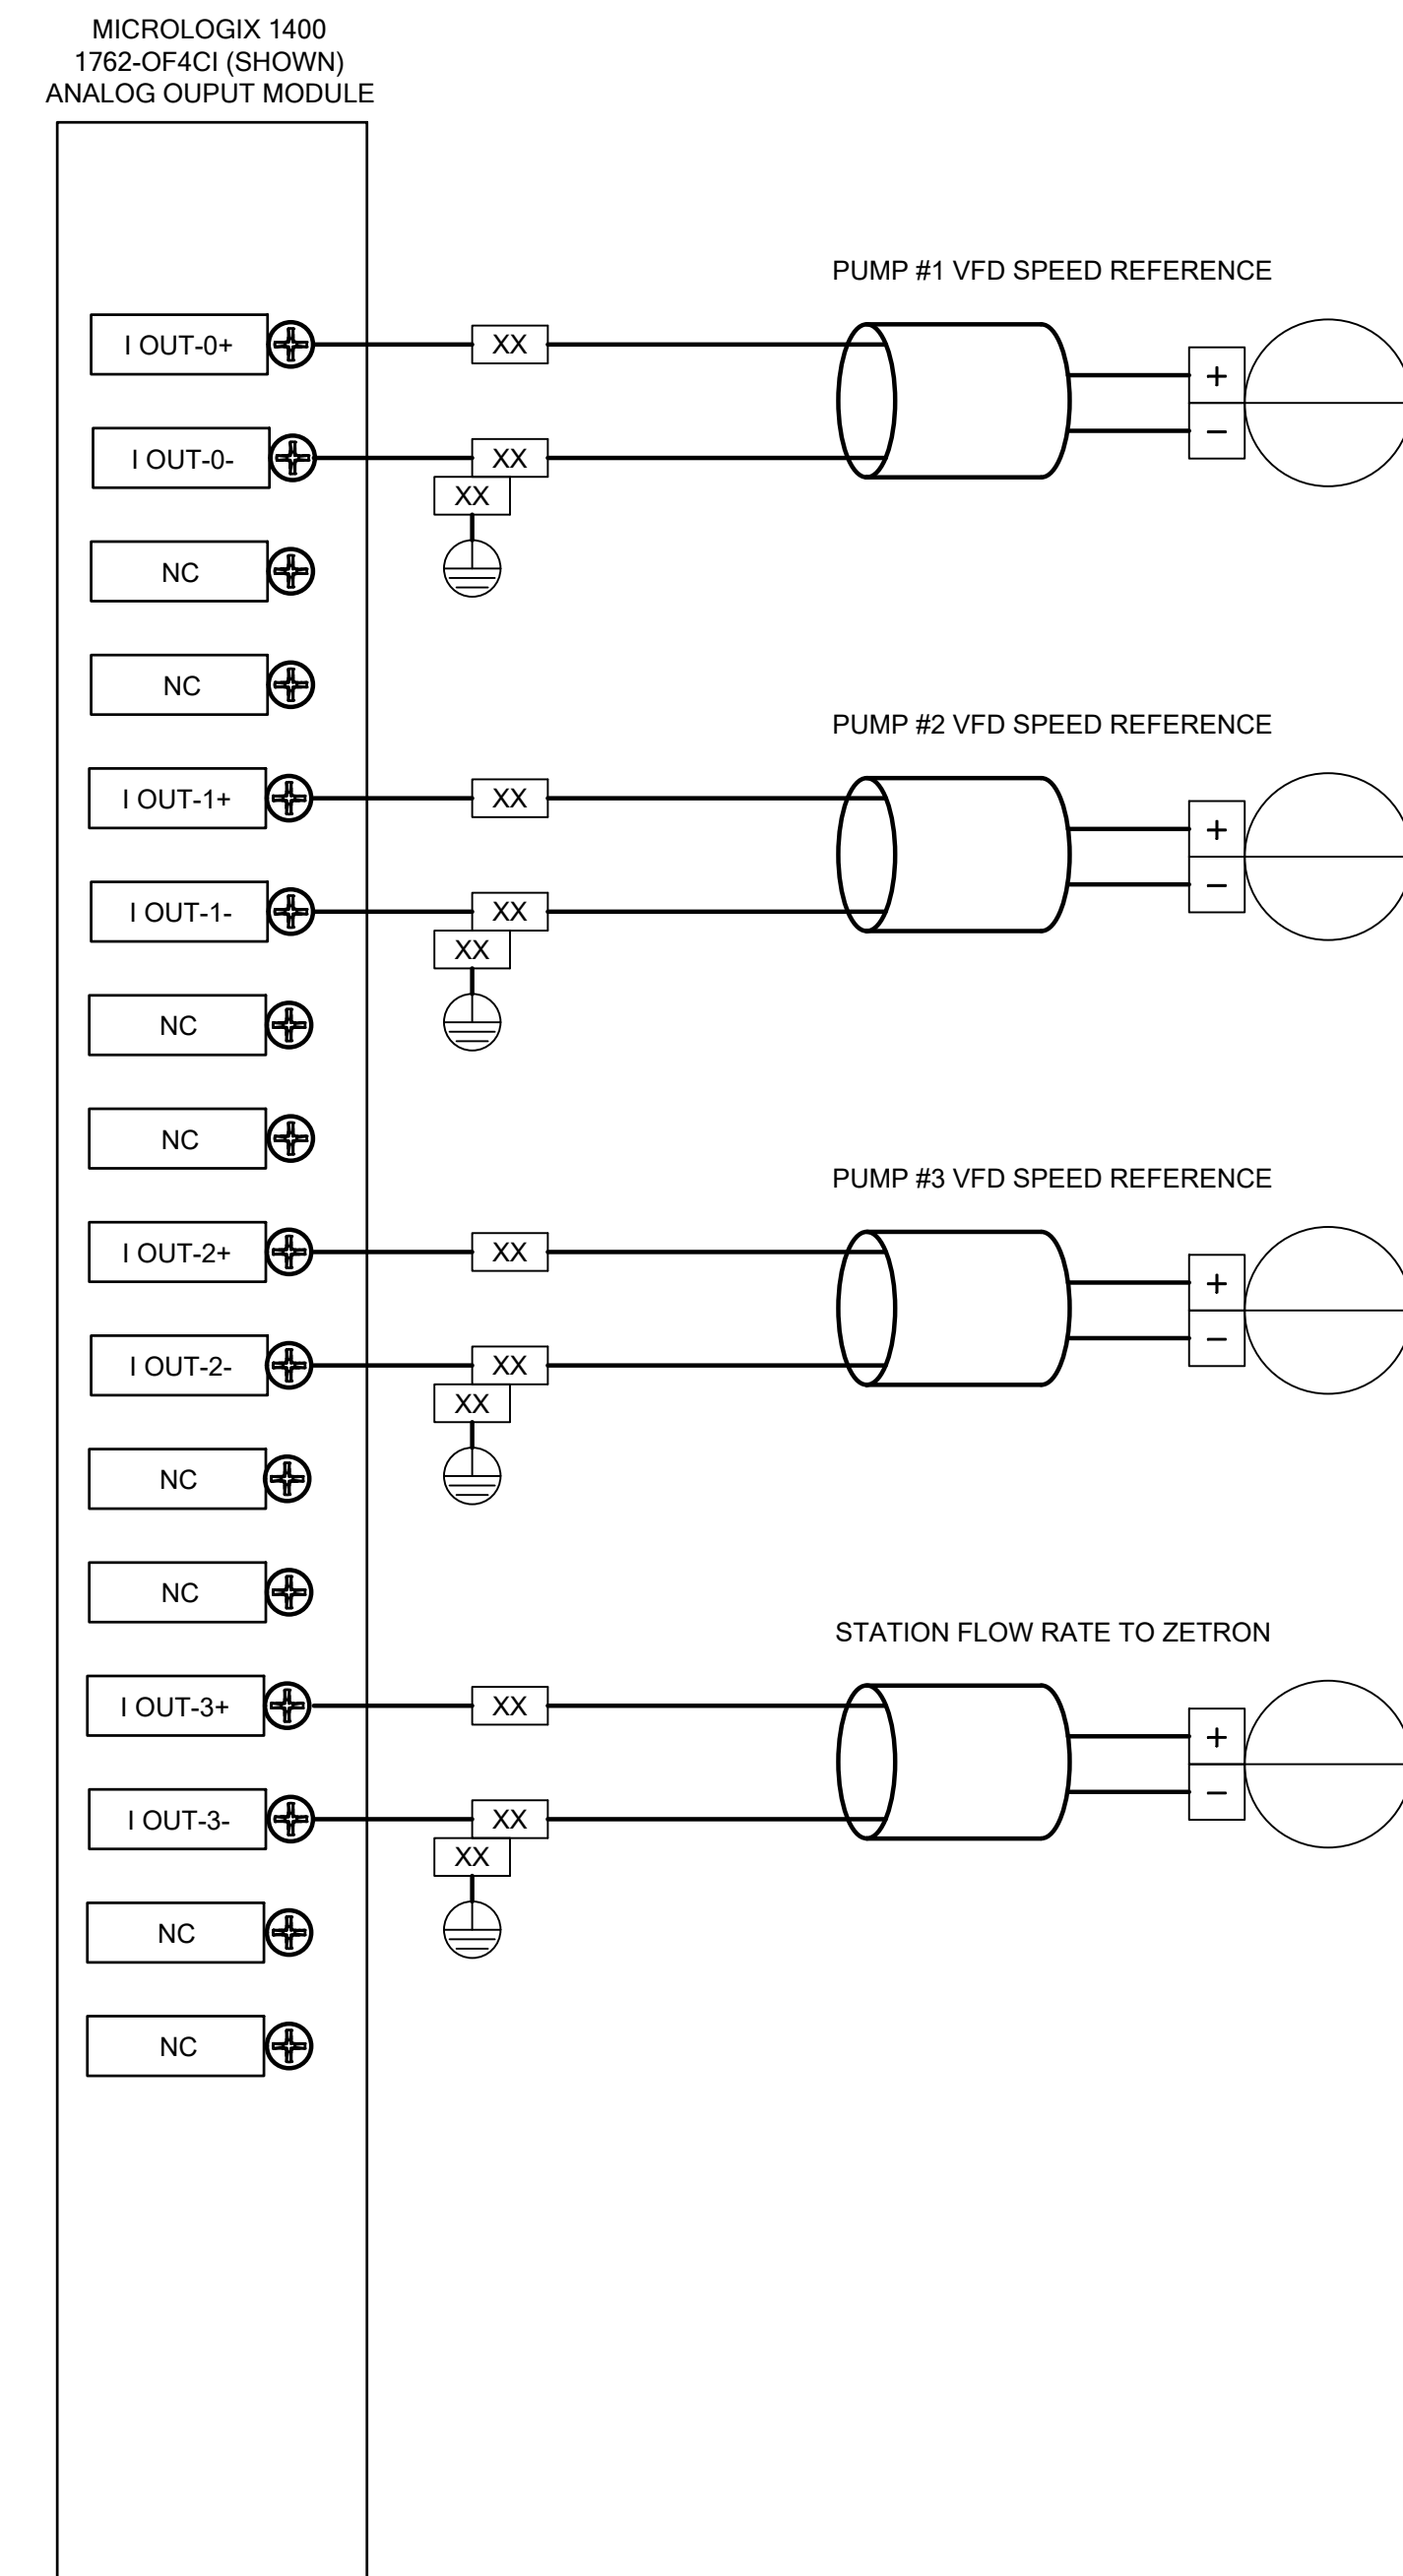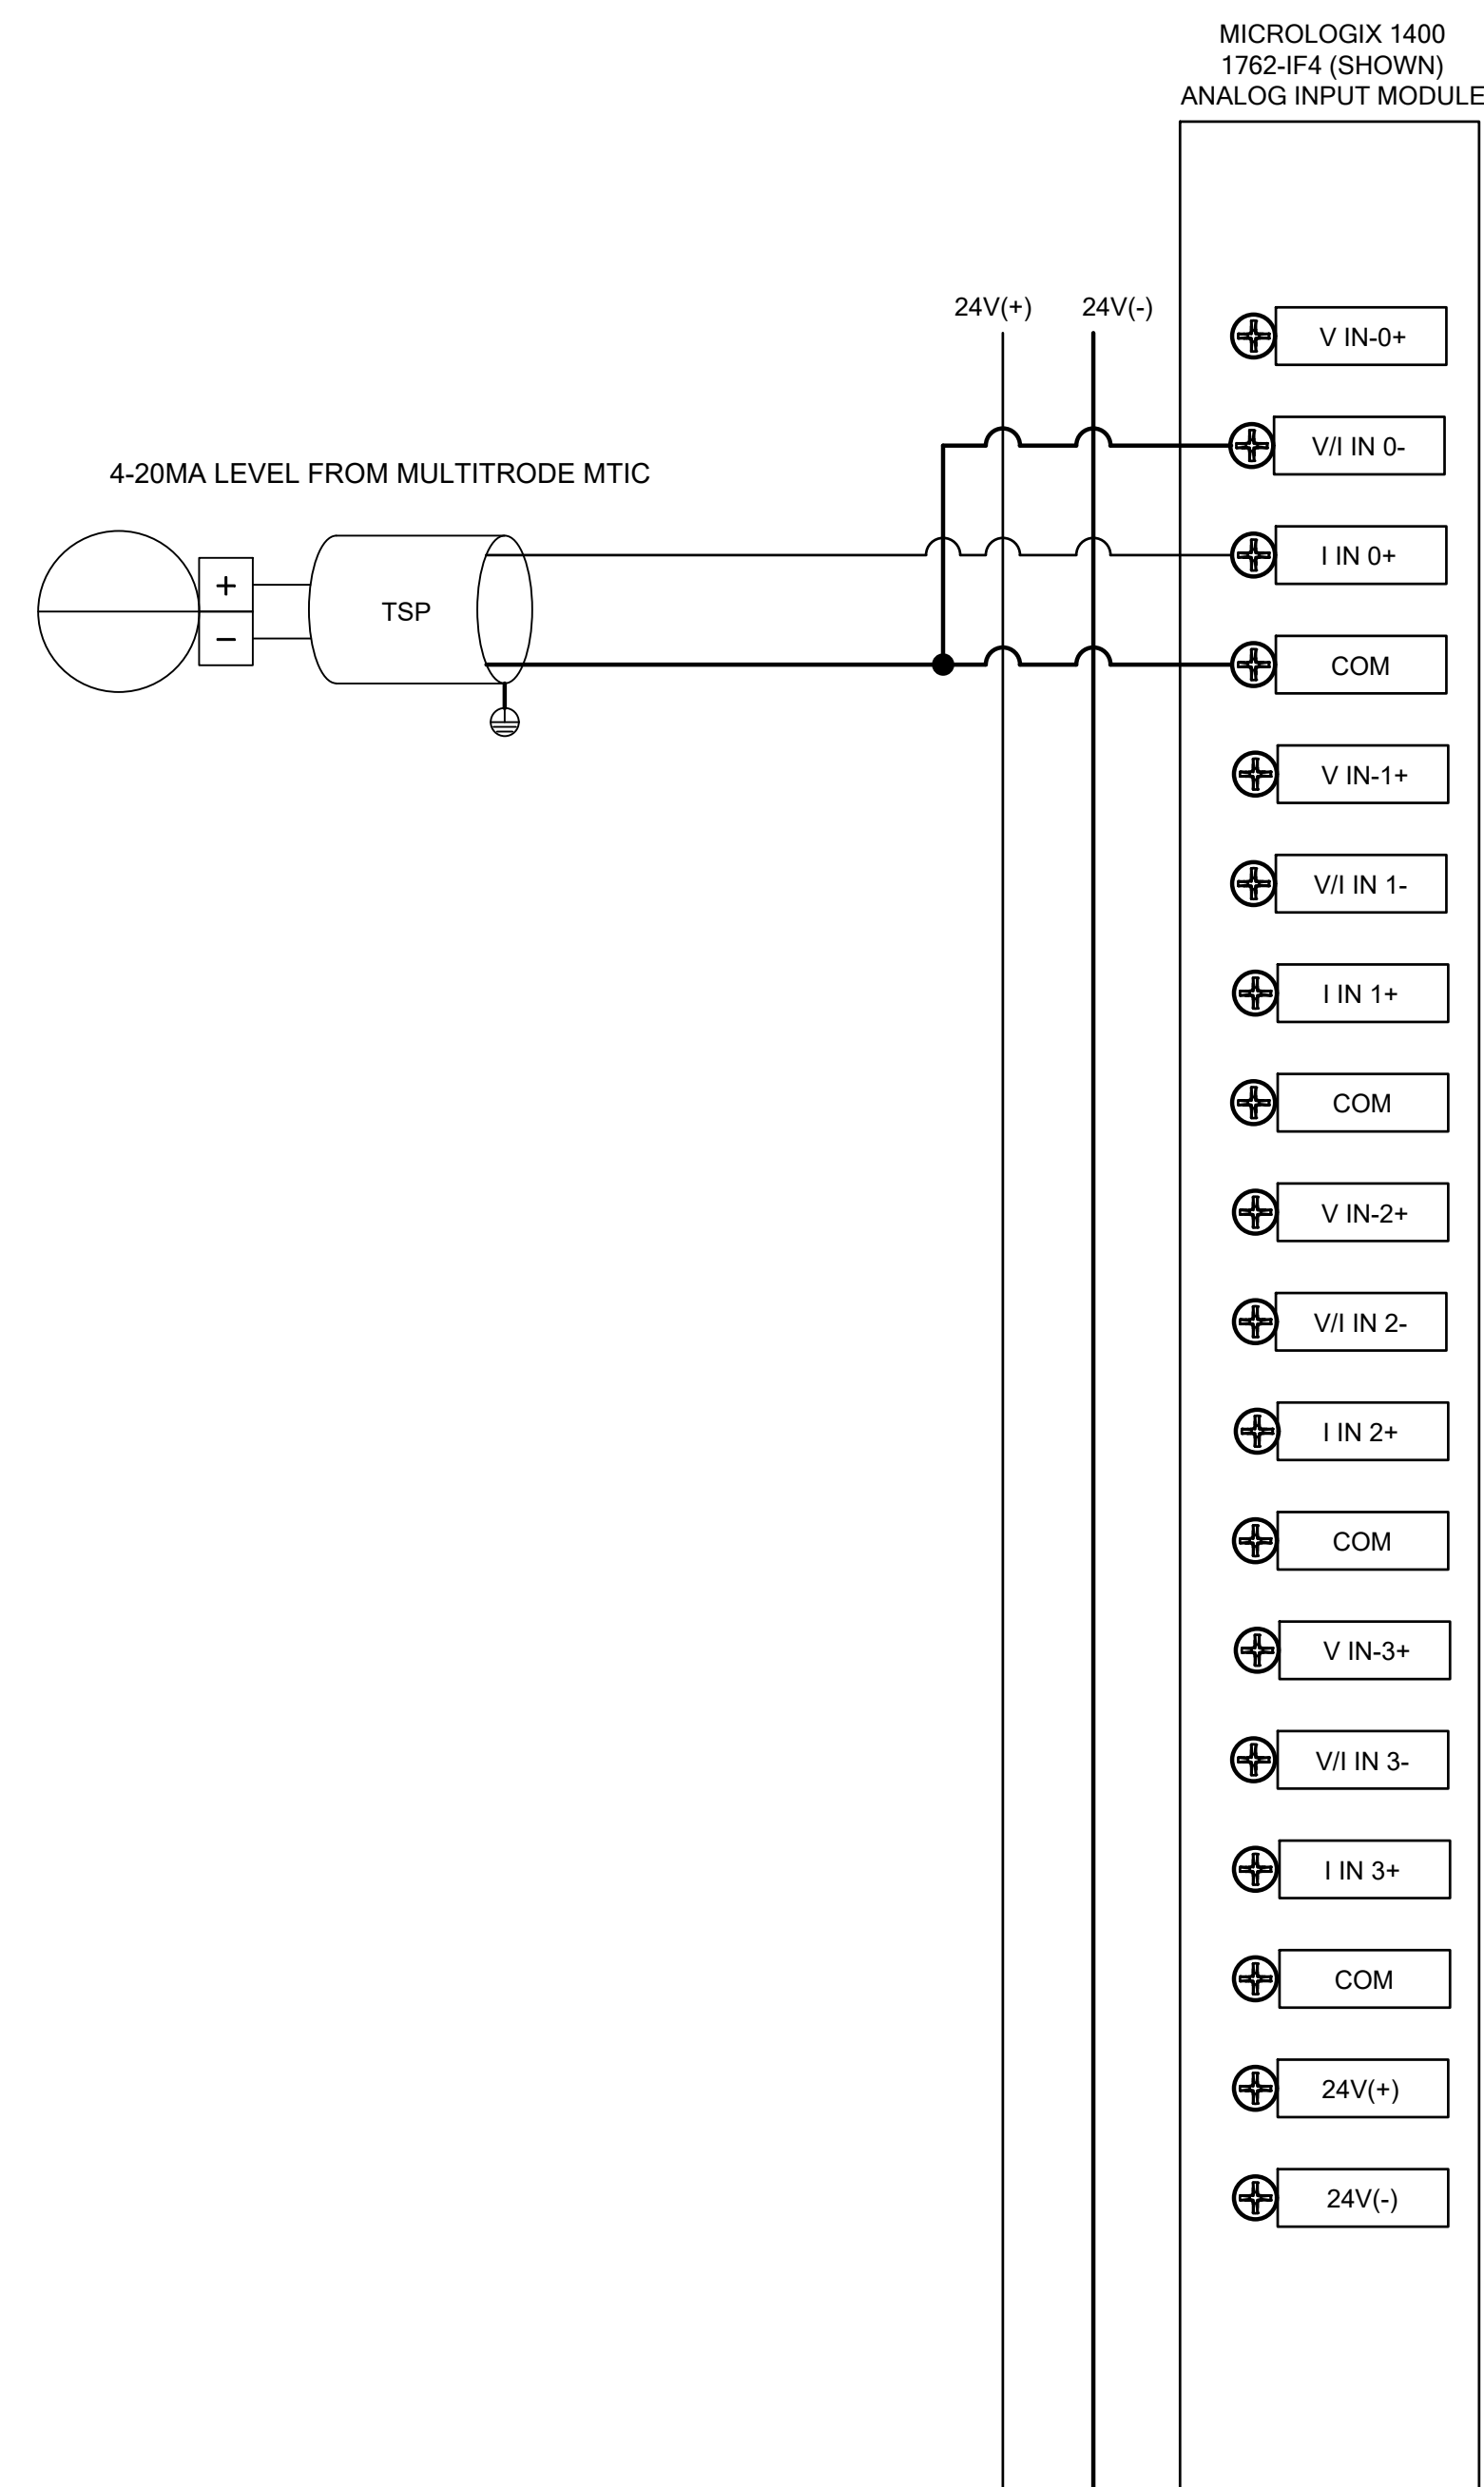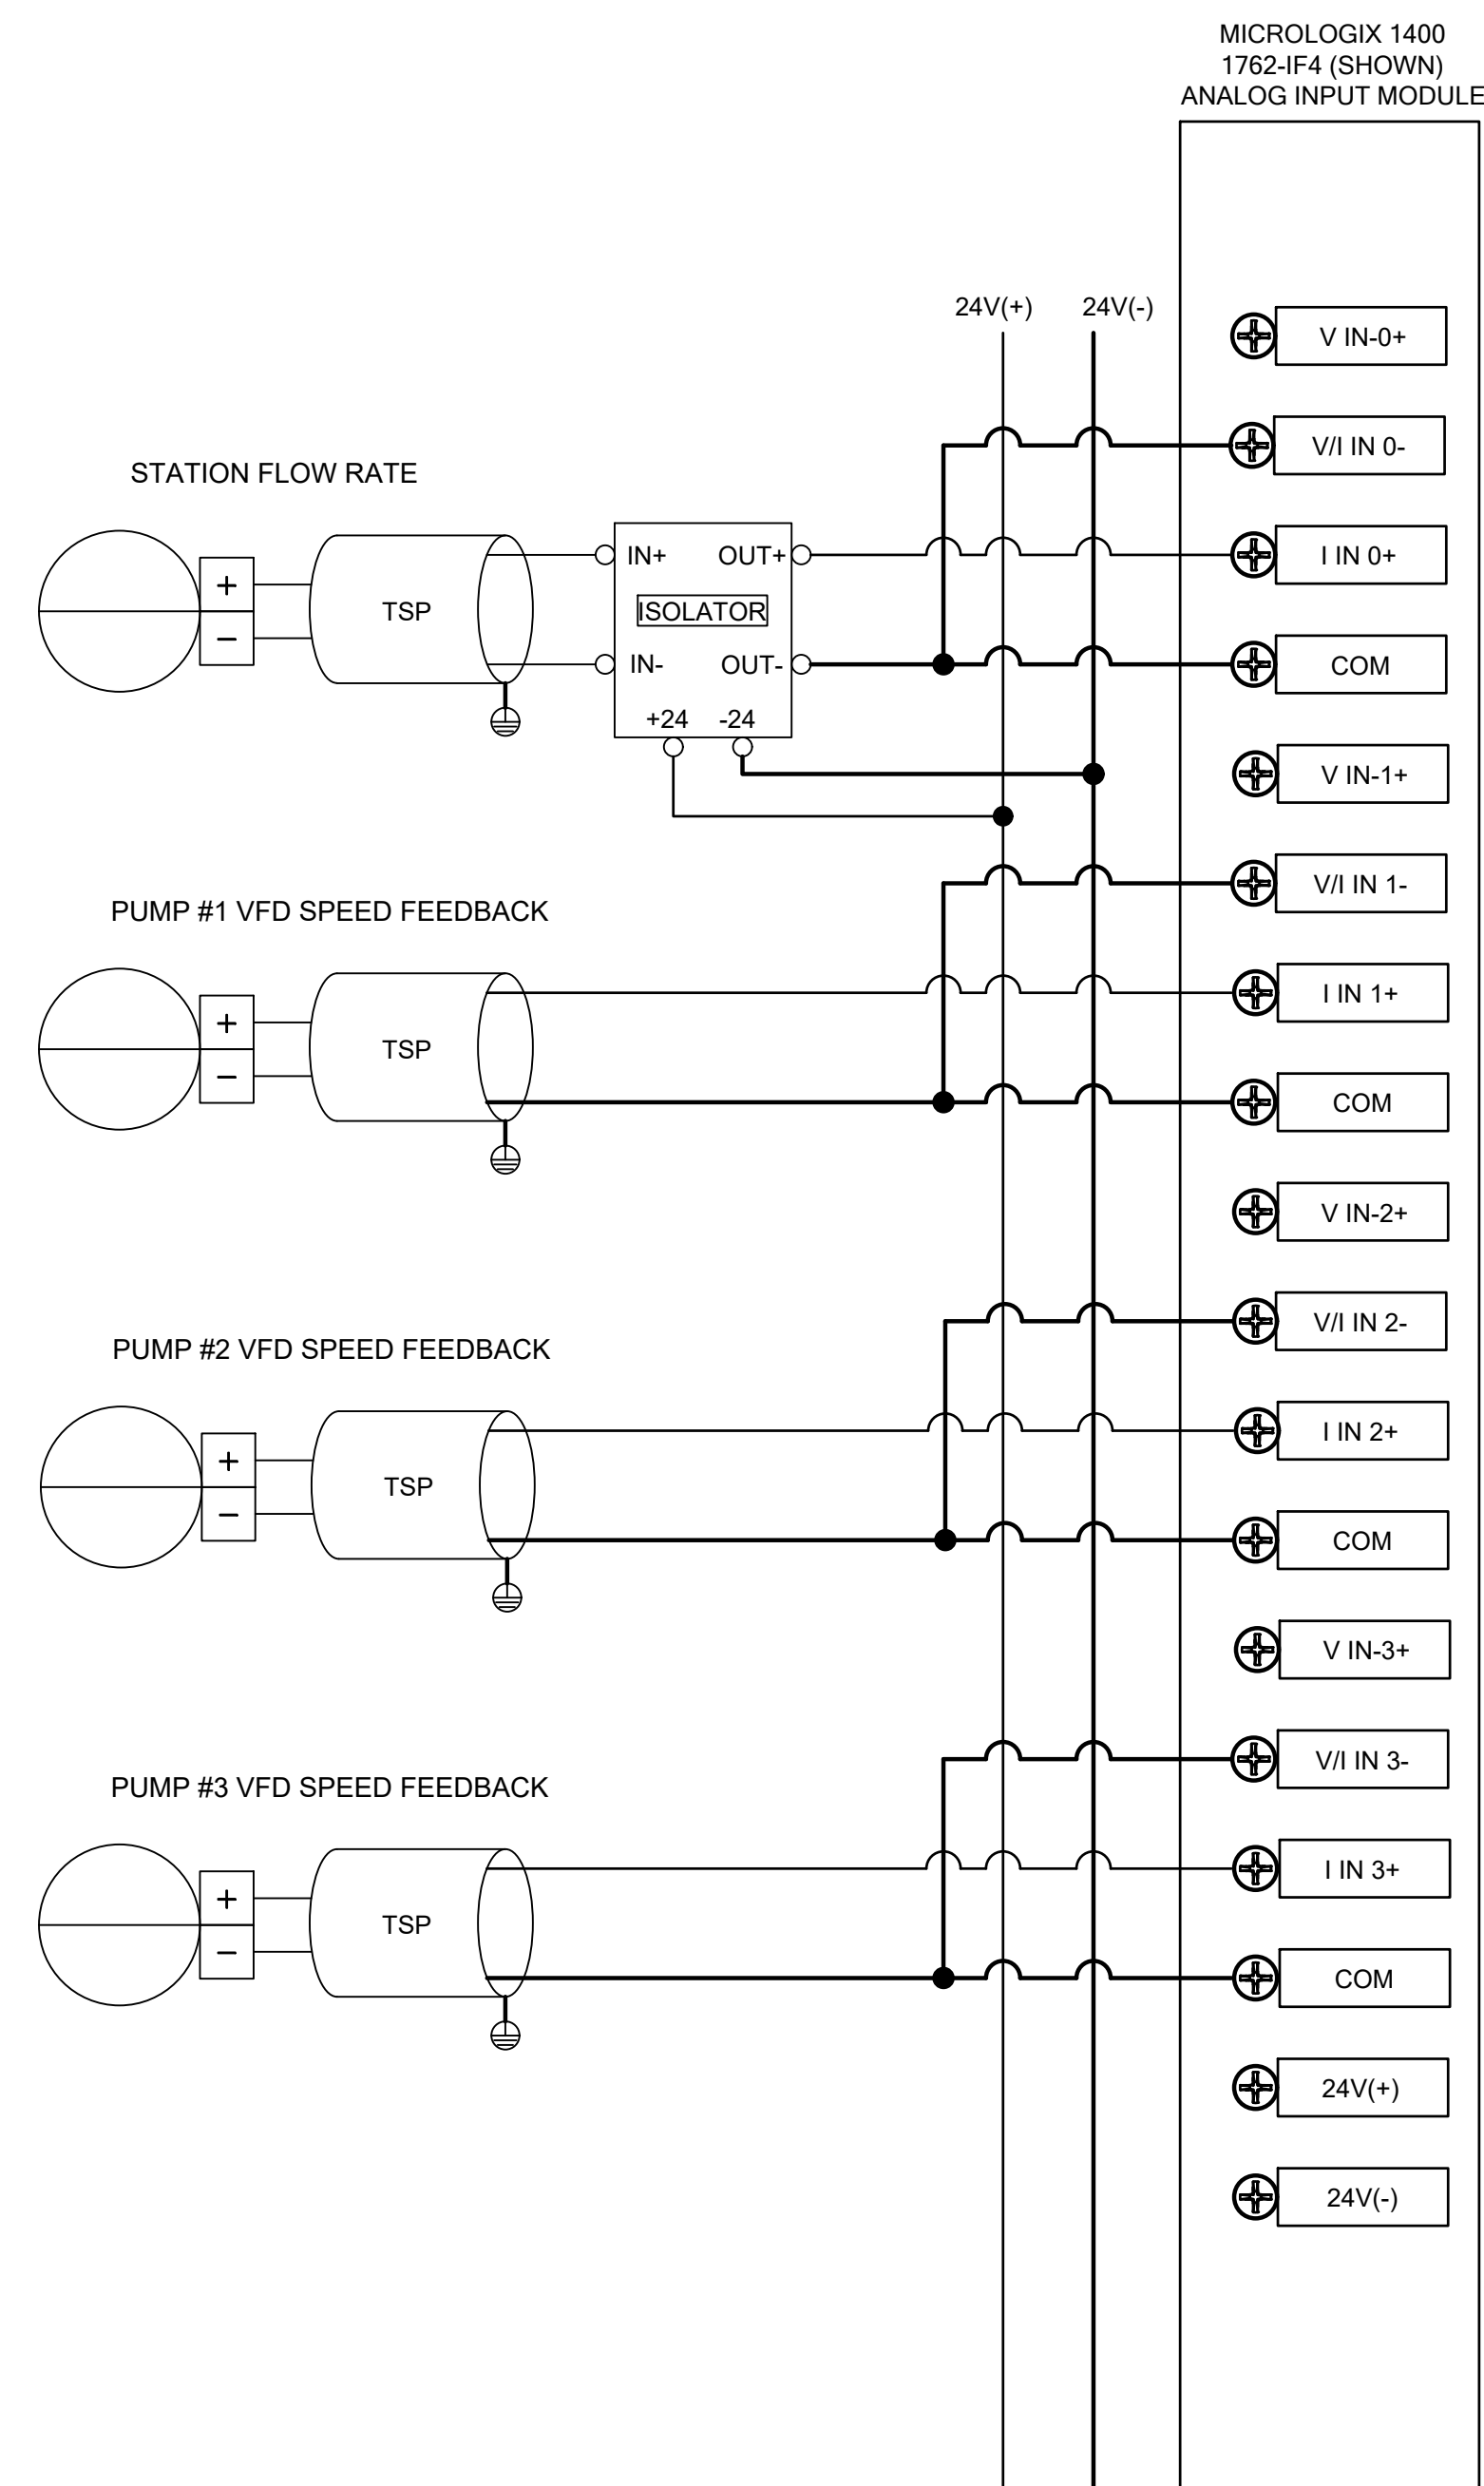


PUMP CONTROL PANEL WIRING DIAGRAM

SCALE: NONE


SCOPE OF WORK NOTES:

THE PANEL LAYOUT SHOWN IS INTENDED TO ESTABLISH THE SCOPE OF WORK AND EXPECTATIONS. FINAL LAYOUT AND DETAILS SHALL BE THE RESPONSIBILITY OF THE MOTOR CONTROL PANEL FABRICATOR. SUBMIT SHOP DRAWINGS FOR REVIEW.

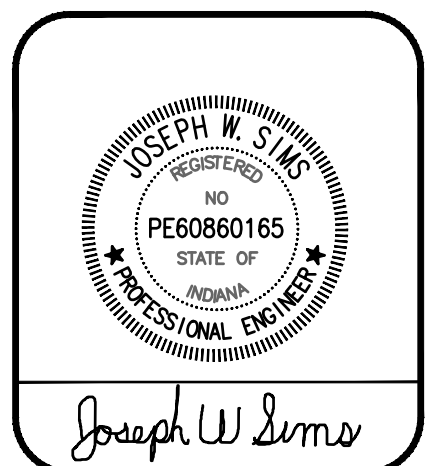[illegible]

**UPHILL RUN LIFT
STATION PROJECT**
200 Commercial St. Nashville, IN. 47448
CITY OF NEW ALBANY WASTEWATER
38 W. 10th STREET, NEW ALBANY, INDIANA 47150
PUMP CONTROL PANEL WIRING DIAGRAM


PLAN DATE: NOVEMBER 8, 2021		
DESIGN: 	CHECK: 	DRAWN:
PROJECT NO. 2018167		
SHEET NO. E-09		

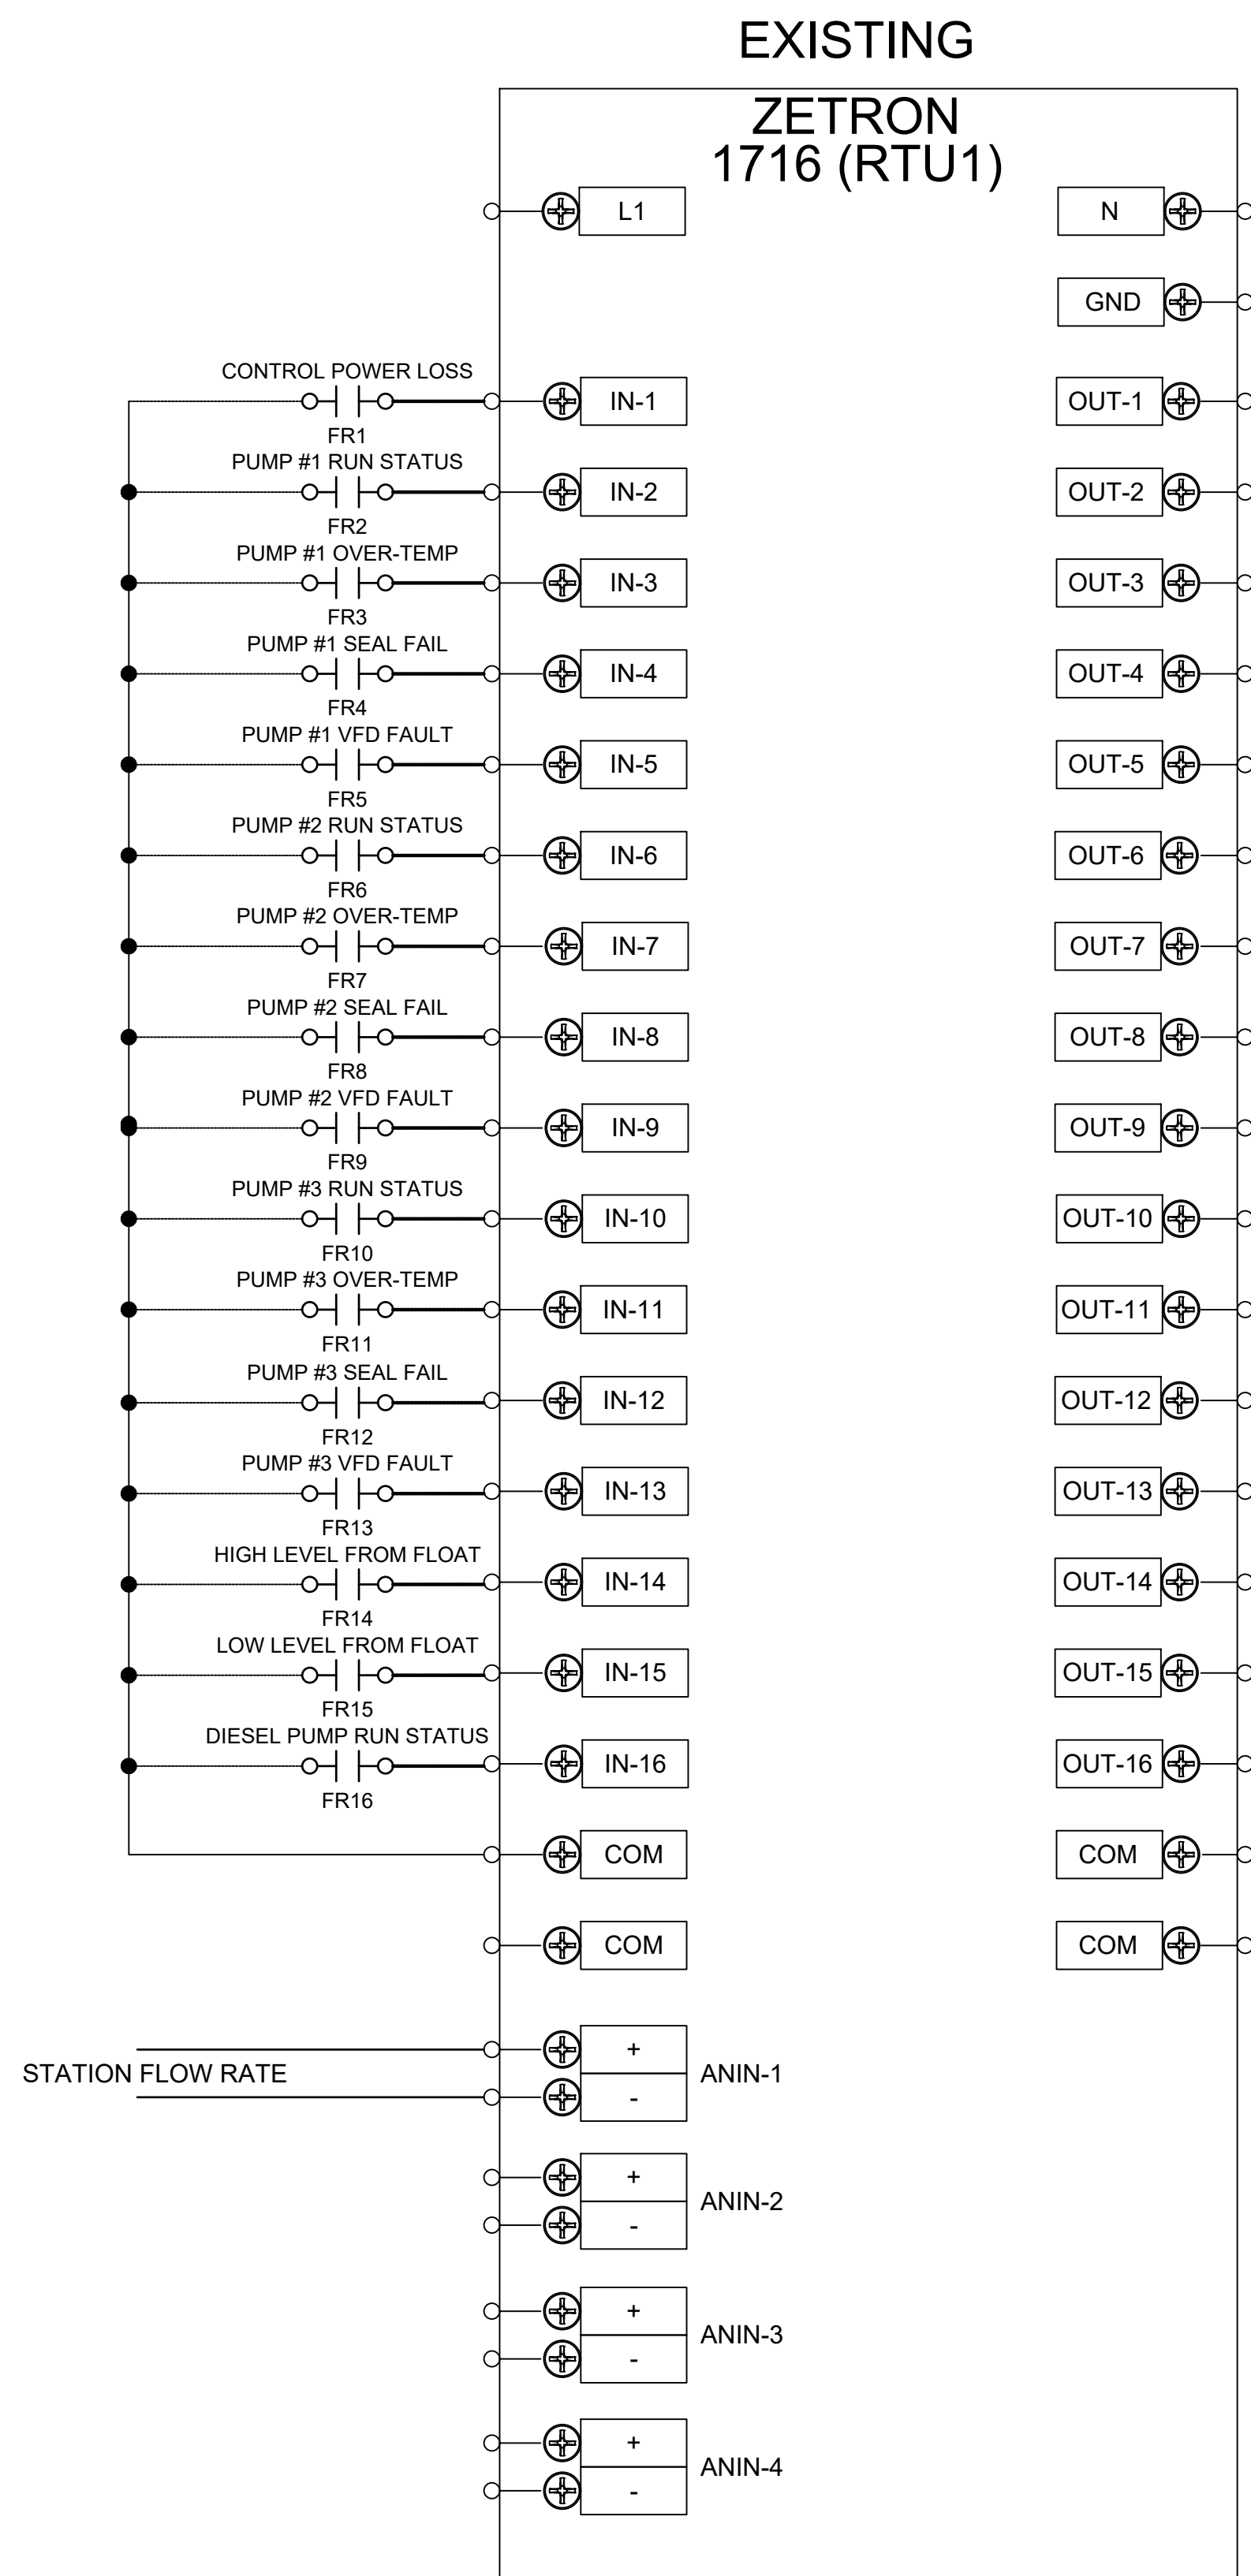


THE PANEL LAYOUT SHOWN IS INTENDED TO ESTABLISH THE SCOPE OF WORK AND EXPECTATIONS. FINAL LAYOUT AND DETAILS SHALL BE THE RESPONSIBILITY OF THE MOTOR CONTROL PANEL FABRICATOR. SUBMIT SHOP DRAWINGS FOR REVIEW.

ELECTRICAL KEYED NOTES:

1. NEW FLOW METER ELECTRONICS (TYPICAL).
2. NEW STAINLESS STEEL 20"x16"x8" WINDOWED ENCLOSURE. FOR FLOW METER.
3. 120V CONTROL POWER GROUND TERMINAL BLOCK.
4. 120V CONTROL POWER NEUTRAL TERMINAL BLOCK.
5. 120V CONTROL POWER CIRCUIT BREAKER.
6. 120V SURGE PROTECTION DEVICE.
7. STAINLESS STEEL UNI-STRUT.
8. RIGID ALUMINUM CONDUIT FOR 4-20MA SIGNAL OUTPUT.
9. RIGID ALUMINUM CONDUIT FOR 120V CONTROL POWER FROM PCP.
10. RIGID ALUMINUM CONDUIT TO PLC FOR SIGNAL WIRING.
11. CONCRETE PAD.
12. NEW 4"x4"x.375" ALUMINUM ANGLE RACK. WELD ALL JOINTS.
13. ALUMINUM OR STAINLESS STEEL MEYER HUBS.
14. 8"x8" STAINLESS STEEL PULL BOX FOR CONTROL AND SIGNAL WIRES/CONDUIT.

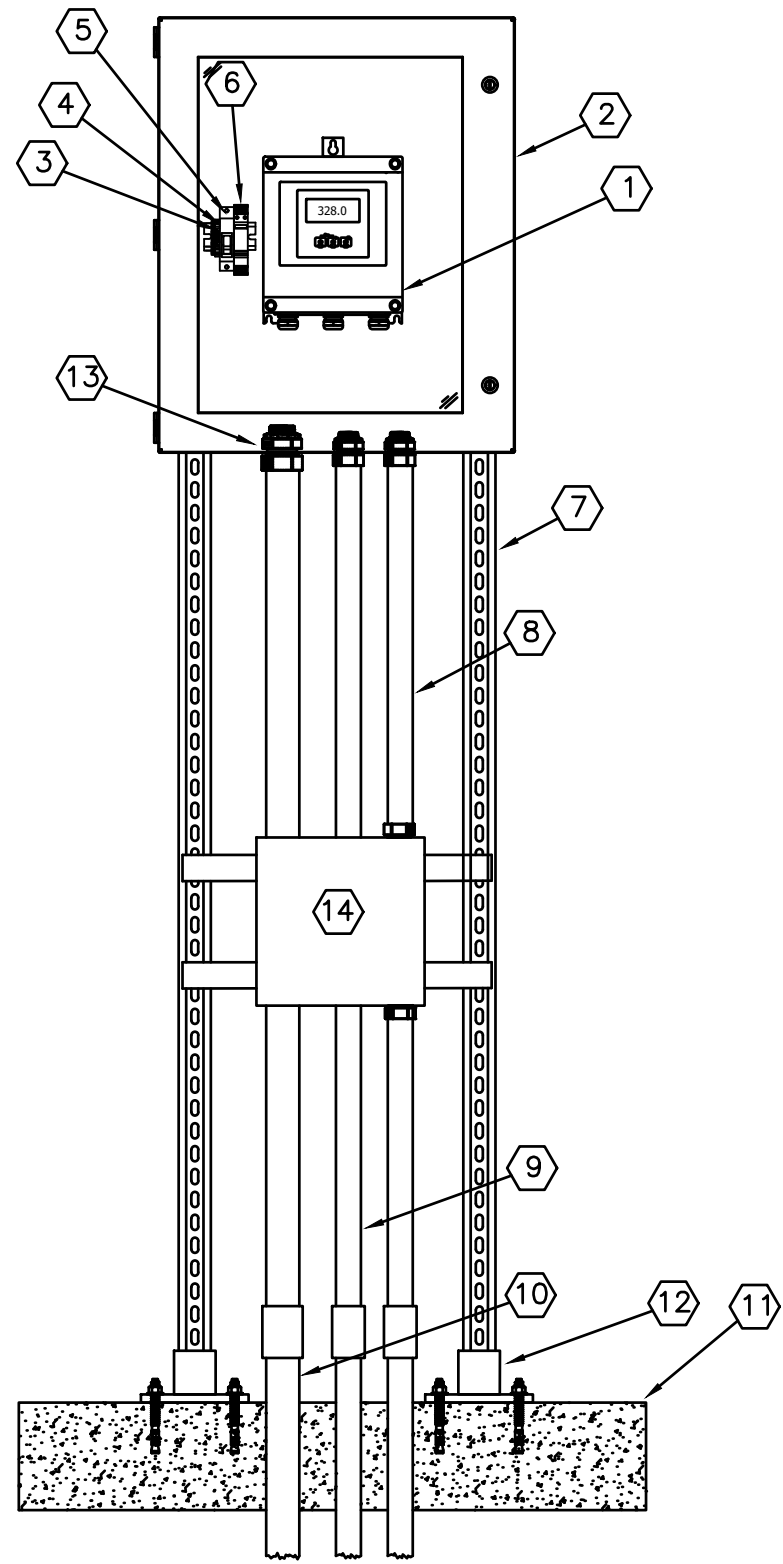

FLOW METER RACK DETAIL
NOT TO SCALE

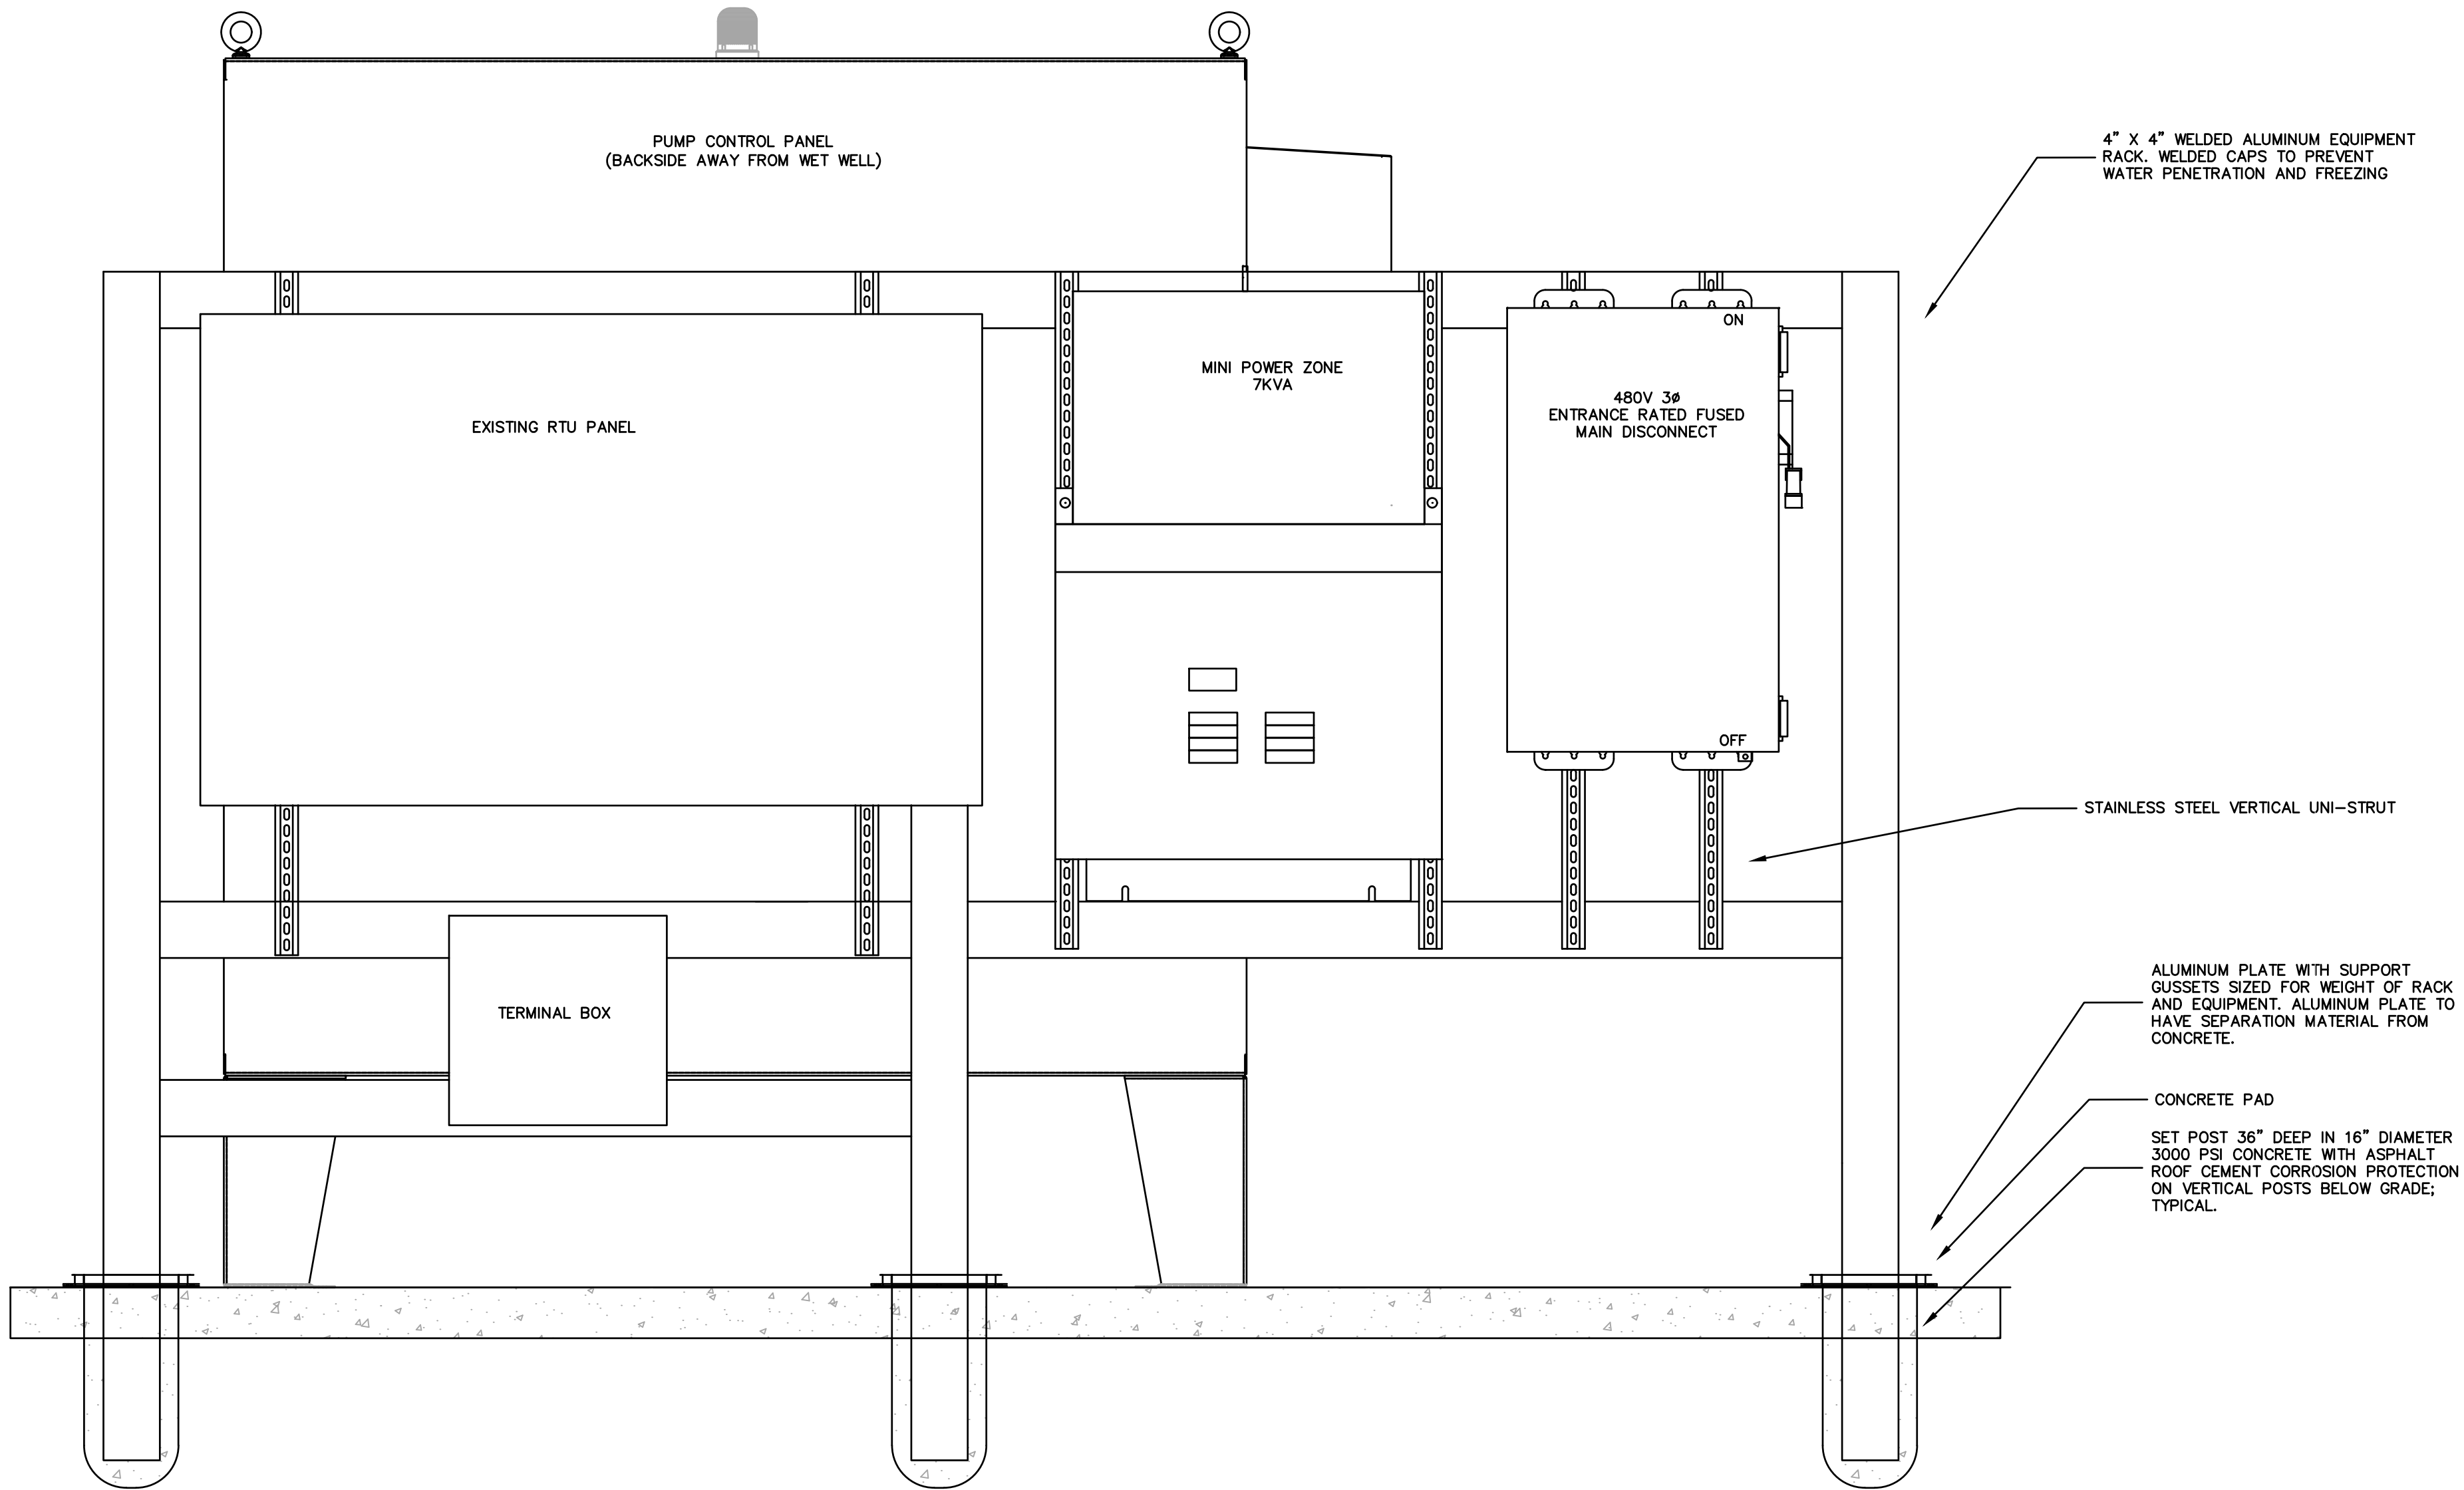

ELECTRICAL EQUIPMENT RACK DETAIL
NOT TO SCALE

BLN

BEAM-LONGEST-NEFF

8125 Casselton Road, Indianapolis, IN 46250
Phone: 317.849.9302
www.BLN.com
Fax: 317.84.4231

REVISIONS AND ISSUES	DATE	BY
1. ISSUE NO.	11-03-2021	TRM
2. ISSUE NO.		
3. ISSUE NO.		
4. ISSUE NO.		
5. ISSUE NO.		
6. ISSUE NO.		
7. ISSUE NO.		
8. ISSUE NO.		
9. ISSUE NO.		
10. ISSUE NO.		
11. ISSUE NO.		
12. ISSUE NO.		
13. ISSUE NO.		
14. ISSUE NO.		
15. ISSUE NO.		
16. ISSUE NO.		
17. ISSUE NO.		
18. ISSUE NO.		
19. ISSUE NO.		
20. ISSUE NO.		

JOSEPH W. STANIS
REGISTERED
PE60860165
STATE OF INDIANA
PROFESSIONAL ENGINEER

Joseph W. Stanis

UPHILL RUN LIFT
STATION PROJECT
200 Commercial St. Nashville, IN. 47448
CITY OF NEW ALBANY WASTEWATER
38 W. 10th STREET, NEW ALBANY, INDIANA 47150

ELECTRICAL DETAILS

PLAN DATE:
NOVEMBER 8, 2021

DESIGN: CHECK: DRAWING:

PROJECT NO.
2018167

SHEET NO.
E-12